

श्री. एच. एस. काशीकर
गुणवत्ता संख्या 667 दिनांक

निविदा सूचना नारायण 23/2025
29-09-2025

चन्द्रभानु गुप्ता लॉ कालेज, चन्द्रावल, बिजनौर, लखनऊ के निर्माणाधीन भवन के फिनिशिंग वर्क में निम्नलिखित कार्य हेतु इच्छुक फर्म अपनी मुहरबंद निविदा 15 अक्टूबर 2025 अपराह्न 3:00 बजे तक भारत सेवा संस्थान के कार्यालय 2-राणा प्रताप मार्ग, मोतीनहल लखनऊ में पंजीकृत डाक अथवा व्यक्तिगत रूप से जमा कर सकते हैं।

1. विद्युतीकरण, इलेक्ट्रीफिकेशन (फिटिंग सहित) फायर फाइटिंग,
2. प्लम्बिंग, बाहरी क्षेत्र में सीवेज एवं रेन हार्वस्टिंग का कार्य
3. एक्सटर्नल कैम्पस डेवलपमेंट एवं पार्किंग वॉटर टैंक सहित
4. इंटर्नल एवं एक्सटर्नल पेन्टिंग कार्य ऐलीवेशन सहित।

नोट : उपरोक्त कार्य के लिए आर्कीटेक्ट के द्वारा बनाया गया नक्शा ऑनलाइन वेबसाइट www.bharatsevasansthan.com पर पूर्ण विवरण के साथ उपलब्ध है। अधिक जानकारी के लिए आर्कीटेक्ट श्री गौरव गुप्ता सम्पर्क सूत्र मो0नं0 9936005439 पर सम्पर्क कर साइट विजिट करते हुए अपनी निविदा प्रस्तुत करें। कार्य में प्रयुक्त वस्तुओं में गुणवत्ता एवं ब्राण्ड का उल्लेख अवश्य हो।

(डा0 जे0एन0मिश्रा)


महामंत्री

भारत सेवा संस्थान

मो0नं0 मो0नं0 9451141938


NOTE:

1. This drawing is a property of De:Ca+Pe Studio and is not to be reproduced copied or handed over in any form except for the purpose for which it is intended.
2. All dimension are in Millimeter except where mentioned.
3. Drawings are not to be scaled written dimensions are to be followed.
4. All discrepancies to be brought to the notice of the Architect and resolved before commencement of any work.

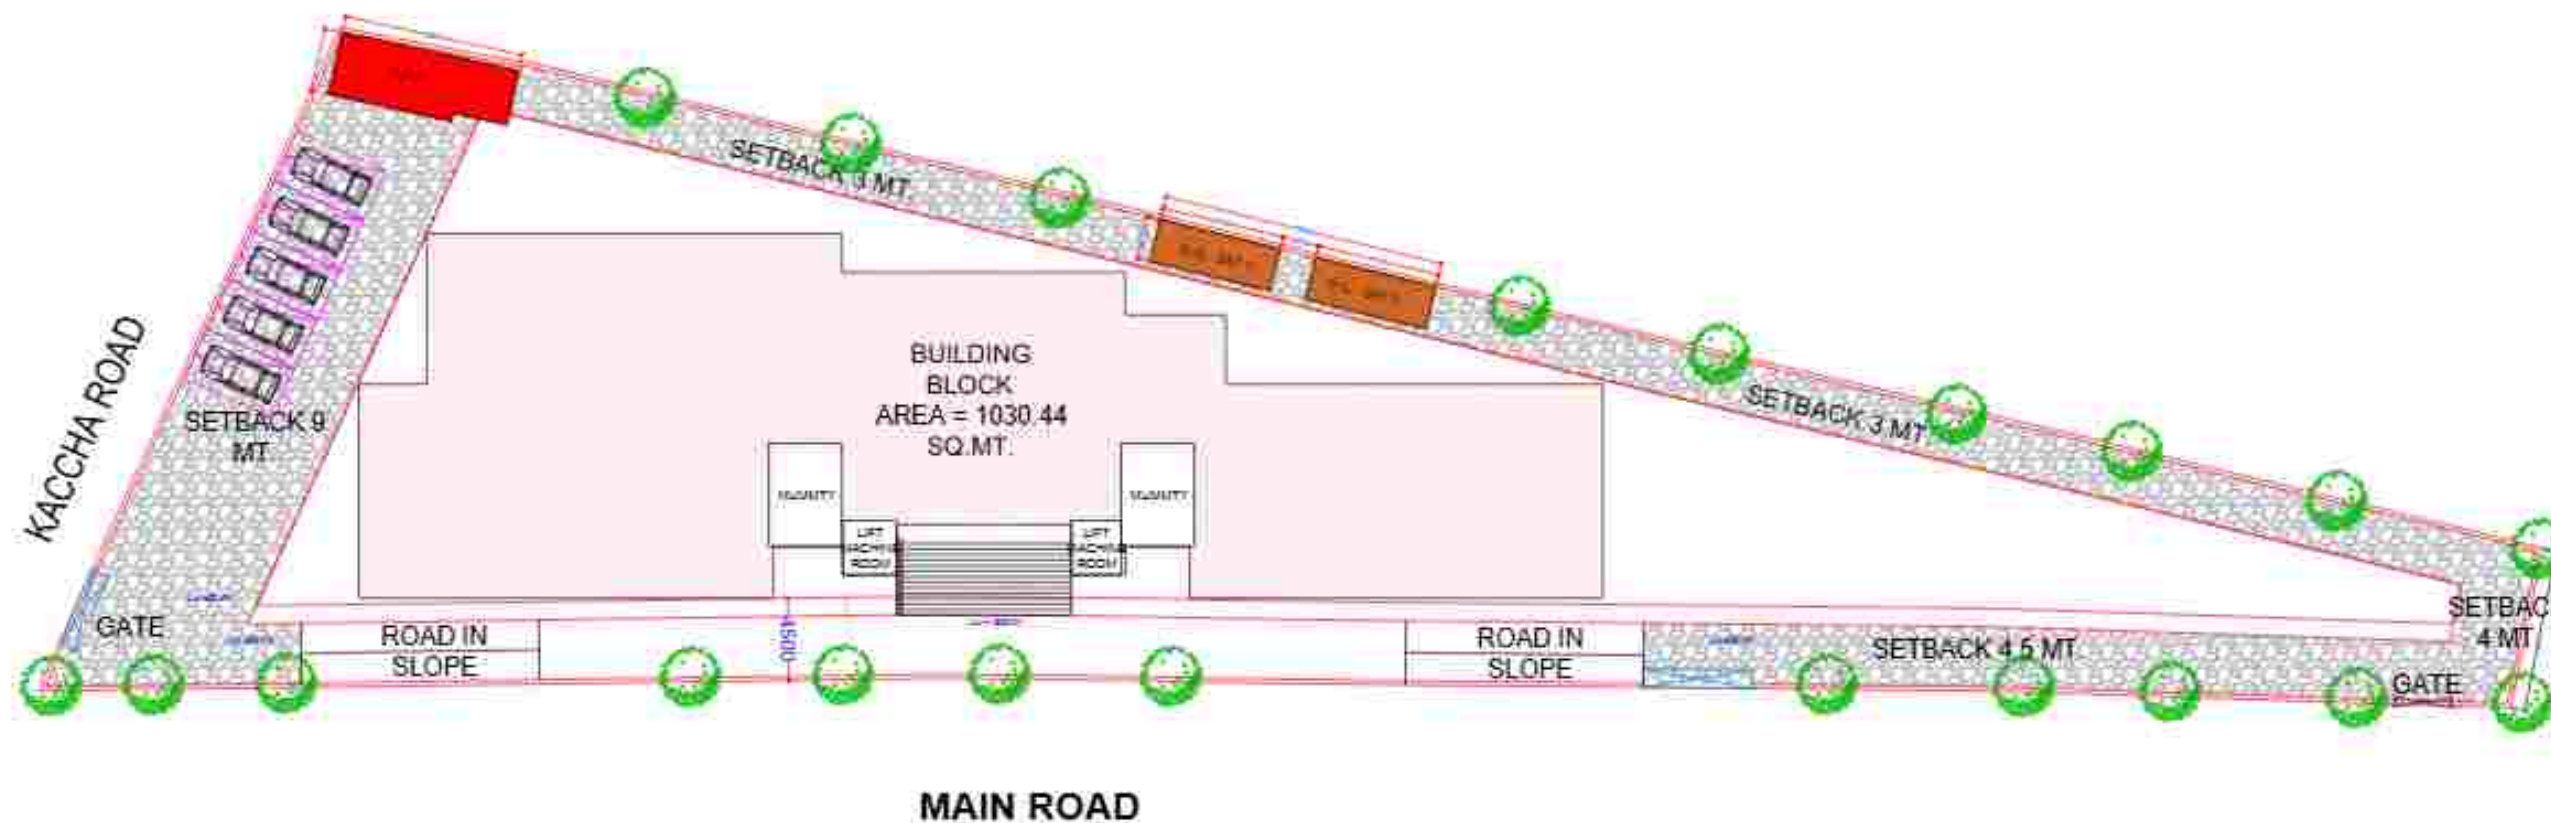

SITE PLAN
SITE AREA - 2950.68 SQM

AREA
Cobble stone- 798 SQMT
D.G Set- 37 SQMT
S.T.P- 33 SQMT

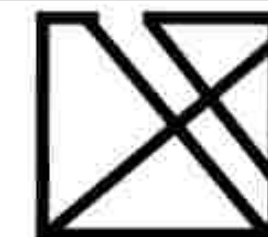

DE: CA+PE STUDIO

Collaborative Architecture & Planning Environment

Head Office - L2-155, Sector G, LDA colony, Ashiyara

Kanpur Road near Roy Hospital, behind Spring Dale

School, Lucknow - 226012

Branch Office - 8/1, Basement, Kalliaji extension,

Delhi - 110019

Contact no - +91 99350 05439

E-Mail- studio.decape18@gmail.com

info.decapestudio@gmail.com



- NOTE:
1. This drawing is a property of De:Ca+Pe Studio and is not to be reproduced copied or handed over in any form except for the purpose for which it is intended.
 2. All dimension are in meters except where mentioned.
 3. Drawings are not to be scaled written dimensions are to be followed.
 4. All discrepancies to be brought to the notice of the Architect and resolved before commencement of any work.

OWNER / CLIENT:

RAJ BHAWAN

ARCHITECTURAL CONSULTANT

AR. GAURAV GUPTA


DRAWING TITLE:

LAW COLLEGE-
ELECTRICAL
(LOWER GROUND FLOOR)

NORTH:-

DRAWN BY: AMISHA SHARMA
SCALE: N.T.S
CHKD BY: AR. GAURAV GUPTA
DATE: 13-09-2025

OFFICE STAMP:

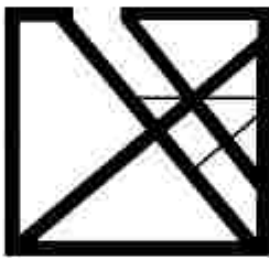

DE: CA+PE STUDIO
COLLABORATIVE ARCHITECTURE & PLANNING ENVIRONMENT
L2-188 SECTOR-0, LDA COLONY, ABHYANA,
KANPUR ROAD, NEAR RDX HOSPITAL,
LUCKNOW-226017
WEBSITE: deapestudio.com
Ph: 935-433564
Email: deapestudio@gmail.com

LEGENDS

MATERIALS	AREA IN SQ.M.
PAINT-1 FOR L.G.F. & U.G.F.	845 SQ.M.
PAINT-2 FOR F.F.,S.F. & MUMTY	890 SQ.M.
PAINT-3 FOR GRC & BRICK MOULDING	900 SQ.M.
GRC	290 SQ.M.

Chandrabhan Gupta Law College

S. NO.	Floor Name	Location	Type	Capacity	Qty
1	Lower Ground Floor	Gallery In front of Class Room 1-4	ABC	6 Kgs	4
		Side Gallery	ABC	6 Kgs	2
		Staff Room (2 Nos.) Inside	ABC	2 Kgs	2
		Waiting / Reception Area	ABC	6 Kgs	1
		Electrical Room Inside	Co2	4.5 Kgs.	1
		Electrical Room Inside	ABC	6 Kgs	1
		Electrical Room Inside (AUTO / Mannual)	ABC & E	580 ML	1
		Pantry (In Side)	ABC	2 Kgs	1
		Gallery In front of Class Room 5-6	ABC	6 Kgs	2
2	Upper Ground Floor	Outside Principal's & Director's Room	ABC	6 Kgs	1
		Library (Inside)	ABC	6 Kgs	1
		I T Room	Clean Agent	2 Kgs	2
		I.T. Room Inside (AUTO / Mannual)	ABC & E	580 ML	1
		Server Rack Suppression System	Clean Agent	2 Kgs	1
		Outside Meeting & Accounts Room	ABC	6 Kgs	1
		Reception & Waiting Area	ABC	6 Kgs	1
		Electrical Room Inside	Co2	4.5 Kgs.	1
		Electrical Room Inside	ABC	6 Kgs	1
		Electrical Room Inside (AUTO / Mannual)	ABC & E	580 ML	1
		Pantry (In Side)	ABC	2 Kgs	1
		Audio Video room Corridore	ABC	6 Kgs	2
		Audio Video Room : 1 (Inside)	ABC	6 Kgs	4
		Audio Video Room : 2 (Inside)	ABC	6 Kgs	4

3	First Floor	Gallery In front of Class Room 1-4	ABC	6 Kgs.	4
		Side Gallery	ABC	6 Kgs.	2
		Staff Room (2 Nos.) Inside	ABC	2 Kgs.	2
		Waiting / Reception Area	ABC	6 Kgs.	1
		Electrical Room Inside	Co2	4.5 Kgs.	1
		Electrical Room Inside	ABC	6 Kgs.	1
		Electrical Room Inside (AUTO / Mannual)	ABC & E	580 ML	1
		Pantry (In Side)	ABC	2 Kgs.	1
		Gallery In front of Class Room 5-6	ABC	6 Kgs.	2
4	Second Floor	Gallery In front of Class Room 1-4	ABC	6 Kgs.	4
		Side Gallery	ABC	6 Kgs.	2
		Staff Room (2 Nos.) Inside	ABC	2 Kgs.	2
		Waiting / Reception Area	ABC	6 Kgs.	1
		Electrical Room Inside	Co2	4.5 Kgs.	1
		Electrical Room Inside	ABC	6 Kgs.	1
		Electrical Room Inside (AUTO / Mannual)	ABC & E	580 ML	1
		Pantry (In Side)	ABC	2 Kgs.	1
		Gallery In front of Class Room 5-6	ABC	6 Kgs.	2
5	Electrical & Genset Area	Inside Electrical Room	Co2	4.5 Kgs.	2
		Inside Electrical Room	ABC	6 Kgs.	1
		Electrical Room Inside (AUTO / Mannual)	ABC & E	580 ML	1
		D. G. Set Room & Area	Foam Type	9 Ltrs	2
		D.G. Set Room & Area	Foam Type	45 Ltrs	1
TOTAL QUANTITY					74

Type	Capacity	Quantity	Remark
ABC	2 Kgs	10	
ABC	6 Kgs	46	
Co2	4.5 Kgs	6	
Foam Type	9 Ltrs	2	
Foam Type	45 Ltrs	1	
Clean Agent	2 Kgs	2	
Clean Agent	2 Kgs	1	Suppression System
ABC & E	580 ML	6	Works Automatically & Manually
	Total Quantity	74	



DE: Ca + Pe Studio

Collaborative Architecture and Planning Environment

Ar. Gaurav Gupta

Principal Architect

B.Arch, M.Arch(S.P.A New Delhi)

Contact no. - 99350 05439

Date- 21/06/24

ESTIMATE FOR MR. C.B.GUPTA FOR LAW COLLEGE
PROJECT ADDRESS : BHARAT SEVA SANSTHAN AT CHANDRAWAL,
BIJNOUR ROAD, LUCKNOW
MADE BY - AR. GAURAV GUPTA , DATE 1- 22/04/2024

ABOUT SITE	AREA ANALYSIS			FOR ACADEMIC BLOCK	FOR HOSTEL BLOCK	
	Site Area			4672.88	491.84	
	FAR			1.5	1.5	
	GROUND COVERAGE			30%	50%	
	PERMISSIBLE GROUND COVERAGE (SQ M)			1401.864	245.92	
	PERMISSIBLE GROUND COVERAGE (SQ FT)			15084.06	2646.1	
	PERMISSIBLE BUILTUP AREA (SQ M)			7009.32	737.76	
	PERMISSIBLE BUILTUP AREA (SQ FT)			75420.29	7938.3	
	HEIGHT OF BUILDING			3	3	
S.NO.	DESCRIPTION	AREA	UNIT	NO.	RATE/SQ.FT	TOTAL
GROUND FLOOR						
CIVIL WORK						
1	ALL CIVIL WORK AS PER STRUCTURAL DRAWING	25,140.1	SQ.FT.		25.0	628,502.4
MEP						
2	ELECTRICAL, PLUMBING, LIFT, STRCUTURE	25,140.1	SQ.FT.		5.0	125,700.5
					TOTAL	754,202.9
FIRST FLOOR						
CIVIL WORK						
5	ALL CIVIL WORK AS PER STRUCTURAL DRAWING	25,140.1	SQ.FT.		25.0	628,502.4
MEP						
6	ELECTRICAL, PLUMBING, LIFT, STRCUTURE	25,140.1	SQ.FT.		5.0	125,700.5
					TOTAL	754,202.9
SECOND FLOOR						
CIVIL WORK						
7	ALL CIVIL WORK AS PER STRUCTURAL DRAWING	25,140.1	SQ.FT.		25.0	628,502.4
MEP						
8	ELECTRICAL, PLUMBING, LIFT, STRCUTURE	25,140.1	SQ.FT.		5.0	125,700.5
					TOTAL	754,202.9
EXTERIOR						
9	FAÇADE	26,769.5	SQ.FT.		20.0	535,389.6
TOTAL CIVIL+MEP COST ESTIMATE						2,797,998.1
TOTAL PROJECT COST		75420.29	SQ.FT.		1000.00	150,840,580.0
TOTAL LANDSCAPING AREA		75420.29	SQ.FT.		30.00	2,262,608.7

Chandrabhan Gupta Law College


S. NO.	Floor Name	Location	Type	Capacity	Qty
1	Lower Ground Floor	Gallery In front of Class Room 1-4	ABC	6 Kgs	4
		Side Gallery	ABC	6 Kgs	2
		Staff Room (2 Nos.) Inside	ABC	2 Kgs	2
		Waiting / Reception Area	ABC	6 Kgs	1
		Electrical Room Inside	Co2	4.5 Kgs.	1
		Electrical Room Inside	ABC	6 Kgs	1
		Electrical Room Inside (AUTO / Mannual)	ABC & E	580 ML	1
		Pantry (In Side)	ABC	2 Kgs	1
		Gallery In front of Class Room 5-6	ABC	6 Kgs	2
2	Upper Ground Floor	Outside Principal's & Director's Room	ABC	6 Kgs	1
		Library (Inside)	ABC	6 Kgs	1
		I T Room	Clean Agent	2 Kgs	2
		I.T. Room Inside (AUTO / Mannual)	ABC & E	580 ML	1
		Server Rack Suppression System	Clean Agent	2 Kgs	1
		Outside Meeting & Accounts Room	ABC	6 Kgs	1
		Reception & Waiting Area	ABC	6 Kgs	1
		Electrical Room Inside	Co2	4.5 Kgs.	1
		Electrical Room Inside	ABC	6 Kgs	1
		Electrical Room Inside (AUTO / Mannual)	ABC & E	580 ML	1
		Pantry (In Side)	ABC	2 Kgs	1
		Audio Video room Corridore	ABC	6 Kgs	2
		Audio Video Room : 1 (Inside)	ABC	6 Kgs	4
		Audio Video Room : 2 (Inside)	ABC	6 Kgs	4

3	First Floor	Gallery In front of Class Room 1-4	ABC	6 Kgs.	4
		Side Gallery	ABC	6 Kgs.	2
		Staff Room (2 Nos.) Inside	ABC	2 Kgs.	2
		Waiting / Reception Area	ABC	6 Kgs.	1
		Electrical Room Inside	Co2	4.5 Kgs.	1
		Electrical Room Inside	ABC	6 Kgs.	1
		Electrical Room Inside (AUTO / Mannual)	ABC & E	580 ML	1
		Pantry (In Side)	ABC	2 Kgs.	1
		Gallery In front of Class Room 5-6	ABC	6 Kgs.	2
4	Second Floor	Gallery In front of Class Room 1-4	ABC	6 Kgs.	4
		Side Gallery	ABC	6 Kgs.	2
		Staff Room (2 Nos.) Inside	ABC	2 Kgs.	2
		Waiting / Reception Area	ABC	6 Kgs.	1
		Electrical Room Inside	Co2	4.5 Kgs.	1
		Electrical Room Inside	ABC	6 Kgs.	1
		Electrical Room Inside (AUTO / Mannual)	ABC & E	580 ML	1
		Pantry (In Side)	ABC	2 Kgs.	1
		Gallery In front of Class Room 5-6	ABC	6 Kgs.	2
5	Electrical & Genset Area	Inside Electrical Room	Co2	4.5 Kgs.	2
		Inside Electrical Room	ABC	6 Kgs.	1
		Electrical Room Inside (AUTO / Mannual)	ABC & E	580 ML	1
		D. G. Set Room & Area	Foam Type	9 Ltrs	2
		D.G. Set Room & Area	Foam Type	45 Ltrs	1
TOTAL QUANTITY					74

Type	Capacity	Quantity	Remark
ABC	2 Kgs	10	
ABC	6 Kgs	46	
Co2	4.5 Kgs	6	
Foam Type	9 Ltrs	2	
Foam Type	45 Ltrs	1	
Clean Agent	2 Kgs	2	
Clean Agent	2 Kgs	1	Suppression System
ABC & E	580 ML	6	Works Automatically & Manually
	Total Quantity	74	

Type	Capacity	Specifications	Quantity	Rate	Amount
ABC	2 Kgs	Stored Pressure Fire Extinguisher, ISI Marked (IS15683:2018), CE and EN Certified, Pure Polyester Powder Coated Body, Forged brass valve with in built Pressure Relief Device and Non Return Valve for Pressure Gauge Port, fitted with Large Dial Pressure Gauge, Stainless Steel Safety pin, High durability Vinyl label (3M make), QR Code label with Printed Serial Number, Nozzle with blow-off cap (Applicable for 4,6,9 kg ABC Models), & EPDM hose (Applicable for 4,6,9 kg Models), with Wall Bracket, Screws with Plugs & Wall Bracket Cover.	10	3420.00	34200.00
ABC	6 Kgs.	Stored Pressure Fire Extinguisher, ISI Marked (IS15683:2018), CE and EN Certified, Pure Polyester Powder Coated Body, Forged brass valve with in built Pressure Relief Device and Non Return Valve for Pressure Gauge Port, fitted with Large Dial Pressure Gauge, Stainless Steel Safety pin, High durability Vinyl label (3M make), QR Code label with Printed Serial Number, Nozzle with blow-off cap (Applicable for 4,6,9 kg ABC Models), & EPDM hose (Applicable for 4,6,9 kg Models), with Wall Bracket, Screws with Plugs & Wall Bracket Cover.	46	5600.00	257600.00
Co2	4.5 Kgs.	Carbon Di-oxide agent Type Fire Extinguisher, ISI Marked (IS15683:2018), CE and EN Certified, Containing CO2 gas having purity 99.7% filled in Seamless Cylinder having approval from Petroleum and Explosives Safety Organisation (PESO), coated with High Glossy PU Paint, ISI marked Dual Spindle Valve with Aluminum Wheel & Collar / Squeeze Grip brass valve, Inbuilt Pressure Relief Device, Aluminium Siphon tube, High durability Vinyl label (3M make), QR Code label with printed serial number, with Wall Bracket, screws & plugs.	6	10800.00	64800.00
Foam Type	9 Ltrs	Stored Pressure Fire Extinguisher, ISI Marked (IS15683:2018), CE and EN Certified, Pure Polyester Powder Coated Body, Forged brass valve with in built Pressure Relief Device and Non Return Valve for Pressure Gauge Port, fitted with Large Dial Pressure Gauge, Stainless Steel Safety pin, High durability Vinyl label (3M make), QR Code label with Printed Serial Number, Nozzle with blow-off cap (Applicable for 4,6,9 kg ABC Models), & EPDM hose (Applicable for 4,6,9 kg Models), with Wall Bracket, Screws with Plugs & Wall Bracket Cover.	2	5300.00	10600.00
Foam Type	60 Ltrs.	Mobile Wheeled Type Fire Extinguisher, ISI Marked (IS16018:2012), CE Certified, Pure Polyester Powder Coated Body with internal and external coating, rugged trolley with heavy duty wheel assembly fitted with shock absorbing bushes, Forged brass Cap Union, High durability Vinyl label (3M make), QR Code label with printed serial number.	1	39600.00	39600.00

Clean Agent	2 Kgs	Stored Pressure Clean Agent Type Fire Extinguisher, ISI Marked (IS15683:2018), CE and EN Certified, filled with UL and FM approved Clean agent for streaming application, Pure Polyester Powder Coated Body, Forged brass valve with in built Pressure Relief Device and Non Return Valve for pressure gauge port fitted with Large Dial pressure gauge, EPDM hose (Applicable for 4, and 6 kg Models), Stainless Steel safety pin, High durability Vinyl label (3M make), QR Code label with printed serial number with Wall Bracket, Screws & Plugs.	2	12500.00	25000.00
Clean Agent Suppression System For Electrical Panel	2 Kgs	Self activating Automatic Fire Supression System for Panel Protection with Pure Polyester Powder Coated cylinder with High durability Vinyl label (3M make), QR Code label with printed Serial Number with automatic fire (heat) detecting UL Listed Polymer Tube, UL & FM Approved Clean Agent and UL Listed Pressure Switch. System should be Certified by National Test House, Dept of Consumer Affairs, Govt. of INDIA.	1	80000.00	80000.00
For Server & Electrical Rooms (ABC & E)	580 ML	Liquid Agent Filled in a Semi Toughed Glass Tube, which should Converts into Co2 & Nitrozen Gas when the temperature reached to 80-84 oC, This should works Operate Automatically at specified temperature, Can be used Manually (Just Thro on the Fire Area), and also increases the Cooling capacity of the water by 20 Times when mixed in a ratio of 6% , In 10 Litre of Water Liquid of One Ampolule is suffucuent.	6	15673.00	94038.00
TOTAL			74		605838.00
Note :	GST & Freight will be extra				

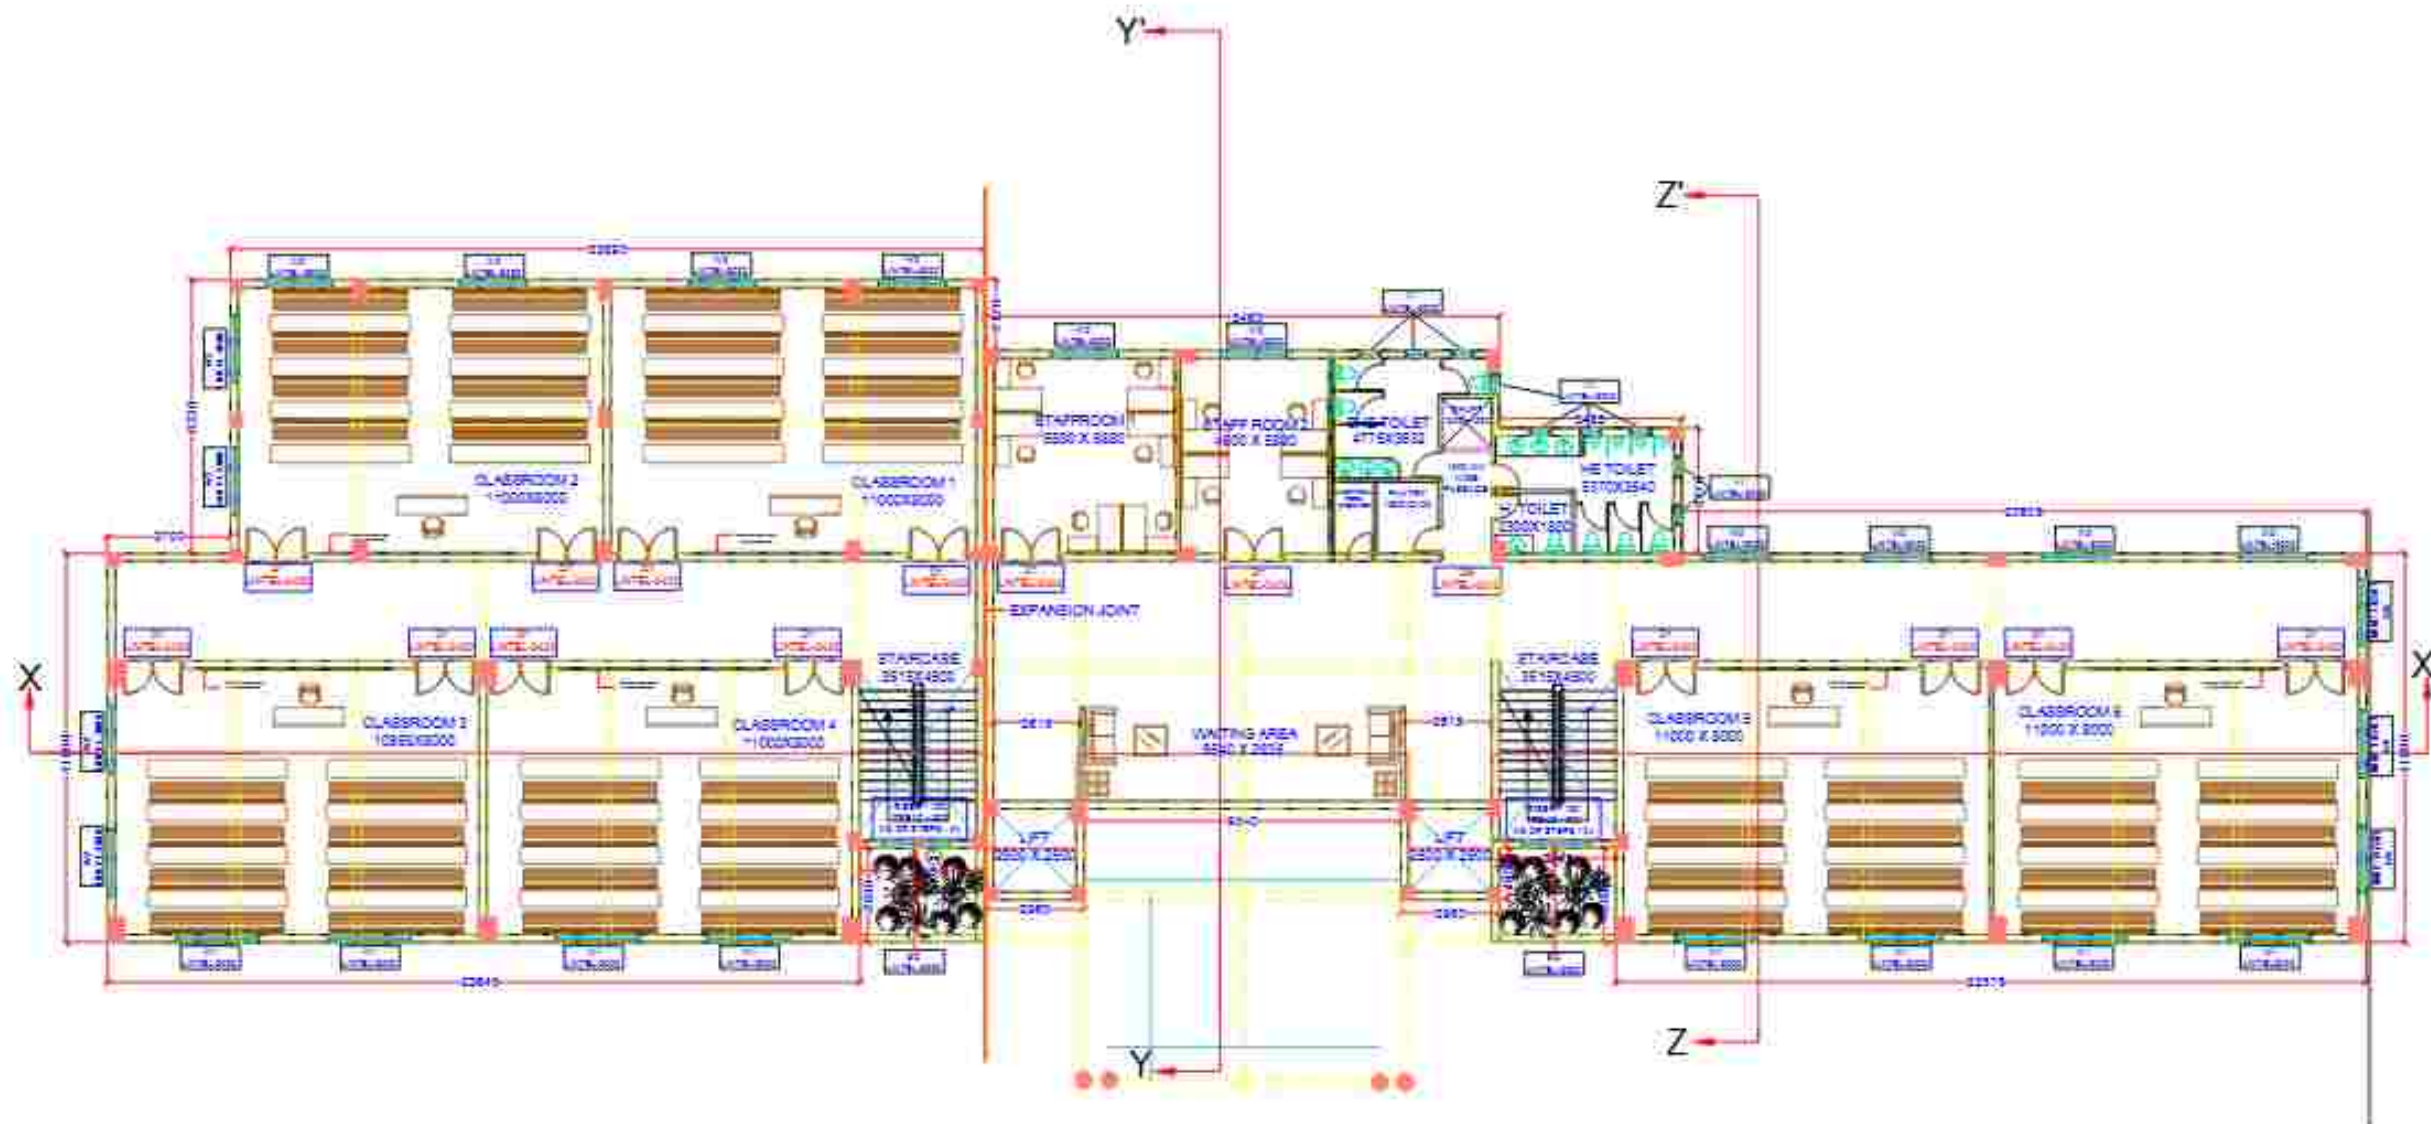

LOWER GROUND FLOOR (1:300)

NOTE:

1. This drawing is a property of De:Ca+Pe Studio and is not to be reproduced copied or handed over in any form except for the purpose for which it is intended.
2. All dimension are in Millimeter except where mentioned.
3. Drawings are not to be scaled written dimensions are to be followed.
4. All discrepancies to be brought to the notice of the Architect and resolved before commencement of any work.

Architectural Consultant
Ar. Gaurav Gupta

Structural Consultant
SBS Consultant

Electrical Consultant
Plumbing Consultant

Client/Owner
BHARAT SEWA SANSTHAN

Project Description
CHANDRABHAN GUPT LAW COLLEGE

North

Drawing Title
SECOND FLOOR DOOR - WINDOW MARKING

Date:- 25/03/2025
Drawn By:- SANA
Checked By:- AR. Gaurav Gupta
Scale:- N.T.S

Project Code:-
Sheet No:-

Office Stamp



DE: CA+PE STUDIO

Collaborative Architecture & Planning Environment


Head Office - L2-155, Sector G, LDA colony, Asthiana
Kanpur Road near Roy Hospital, behind Spring Dale
School, Lucknow - 226012

Branch Office - 8/1, Basement, Kalkaji extension,
Delhi - 110019

Contact no - +91 99350 05439
E-Mail- studio.decape18@gmail.com
info.decapestudio@gmail.com

NOTE:

1. This drawing is a property of De:Ca+Pe Studio and is not to be reproduced copied or handed over in any form except for the purpose for which it is intended.
2. All dimension are in Millimeter except where mentioned.
3. Drawings are not to be scaled written dimensions are to be followed.
4. All discrepancies to be brought to the notice of the Architect and resolved before commencement of any work.

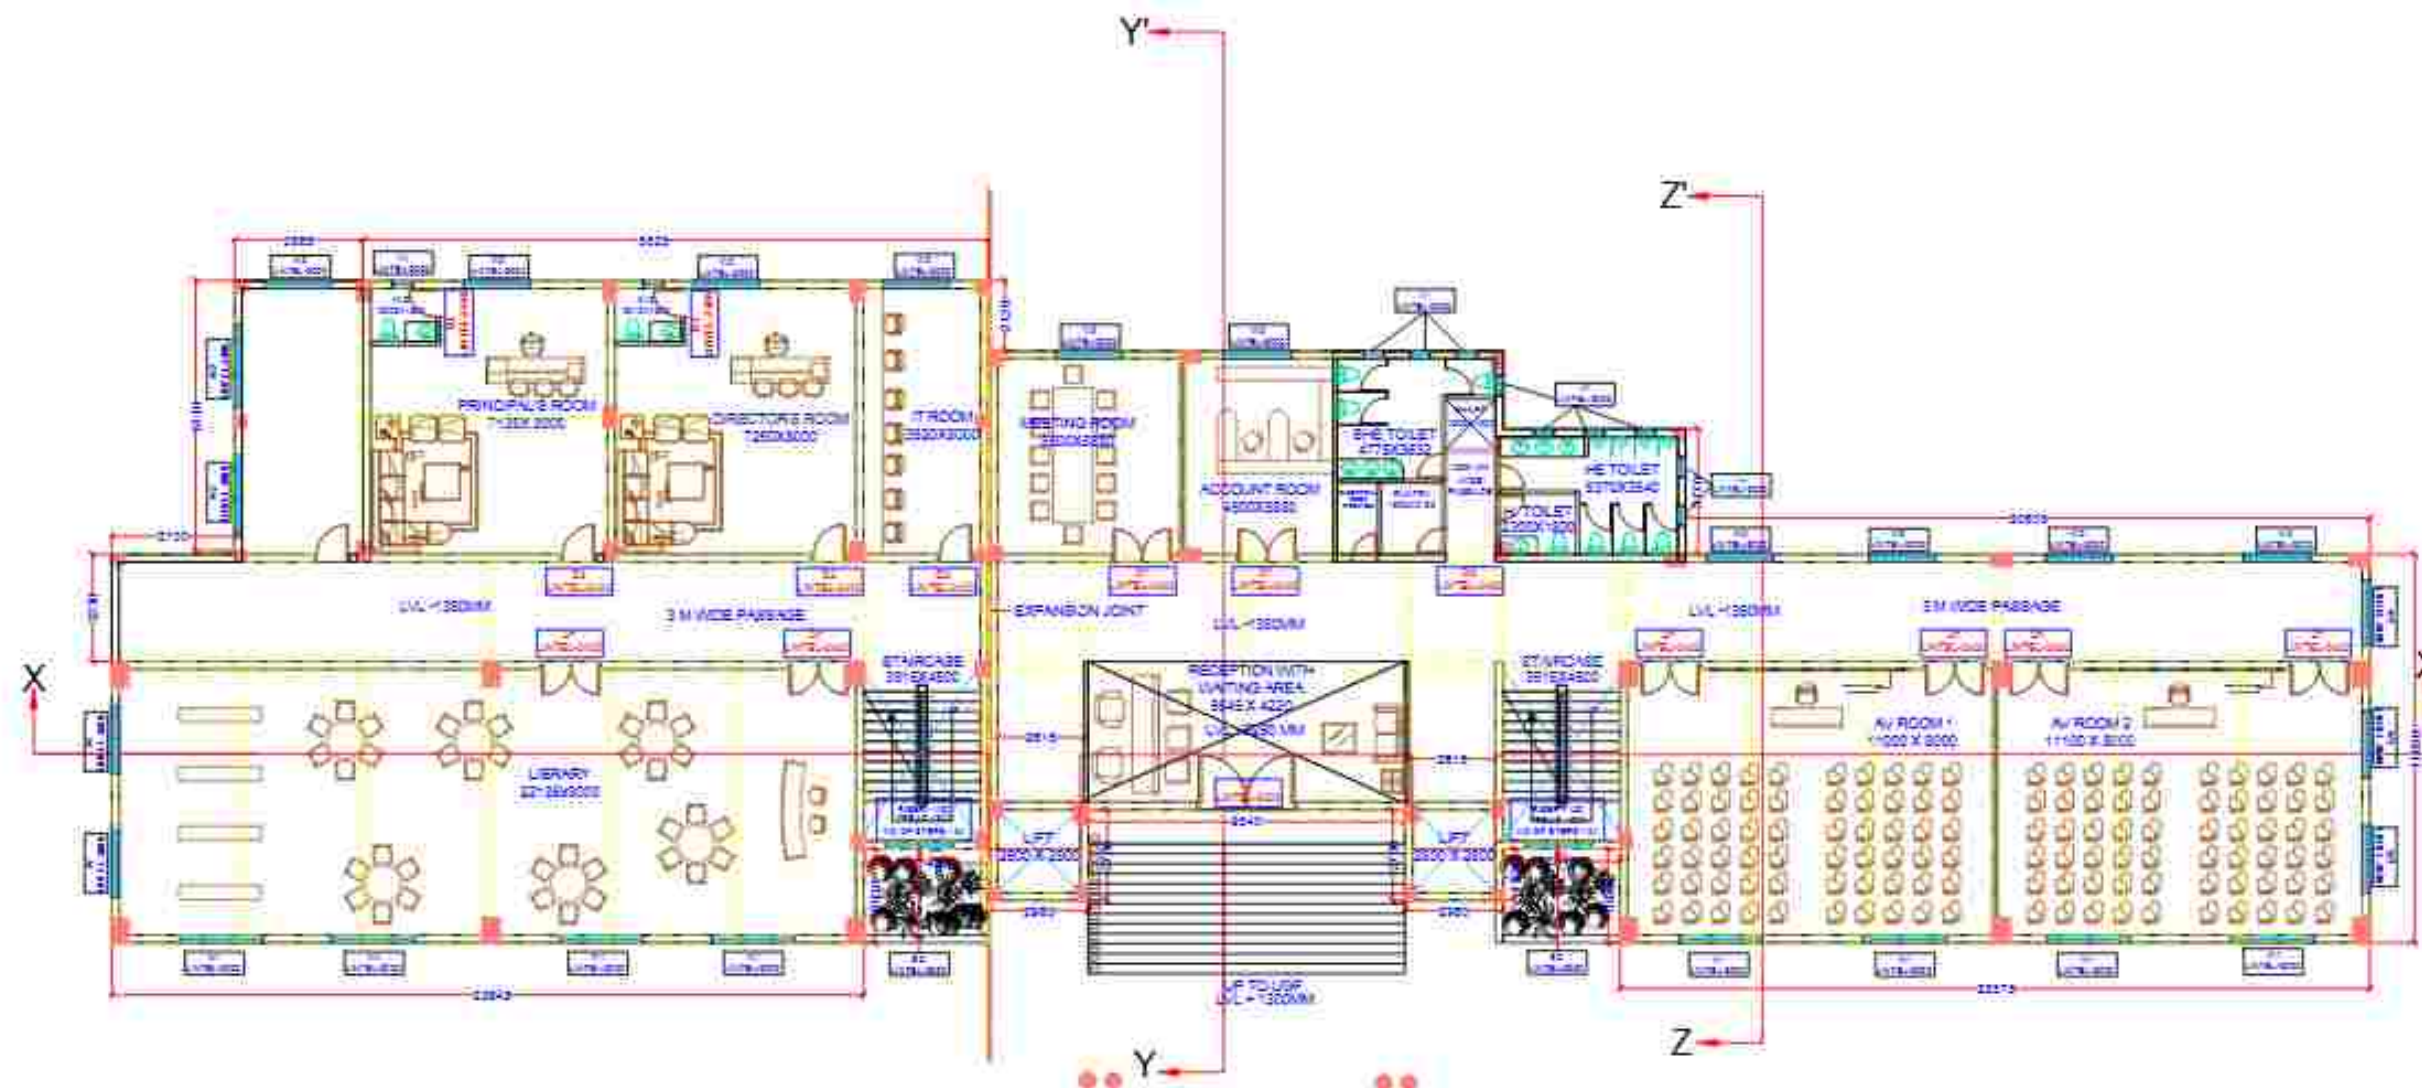

UPPER GROUND FLOOR (1:300)

Architectural Consultant
Ar. Gaurav Gupta

Structural Consultant
SBS Consultant

Electrical Consultant
Plumbing Consultant

Client/Owner
BHARAT SEWA SANSTHAN

Project Description
CHANDRABHAN GUPT LAW
COLLEGE


North

Drawing Title
SECOND FLOOR DOOR - WINDOW MARKING

Date: - 25/03/2025
Drawn By: - SANA
Checked By: - AR. Gaurav Gupta
Scale: - N.T.S

Project Code:-
Sheet No.:-

Office Stamp

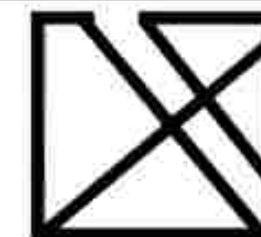

DE: CA+PE STUDIO

Collaborative Architecture & Planning Environment

Head Office - L2-155, Sector G, LDA colony, Ashiyana
Kanpur Road near Roy Hospital, behind Spring Dale
School, Lucknow - 226012

Branch Office - 8/1, Basement, Kalkaji extension,
Delhi - 110019


Contact no - +91 99350 05439

E-Mail- studio.decape18@gmail.com

info.decapestudio@gmail.com

NOTE:

1. This drawing is a property of De:Ca+Pe Studio and is not to be reproduced copied or handed over in any form except for the purpose for which it is intended.
2. All dimension are in Millimeter except where mentioned.
3. Drawings are not to be scaled written dimensions are to be followed.
4. All discrepancies to be brought to the notice of the Architect and resolved before commencement of any work.

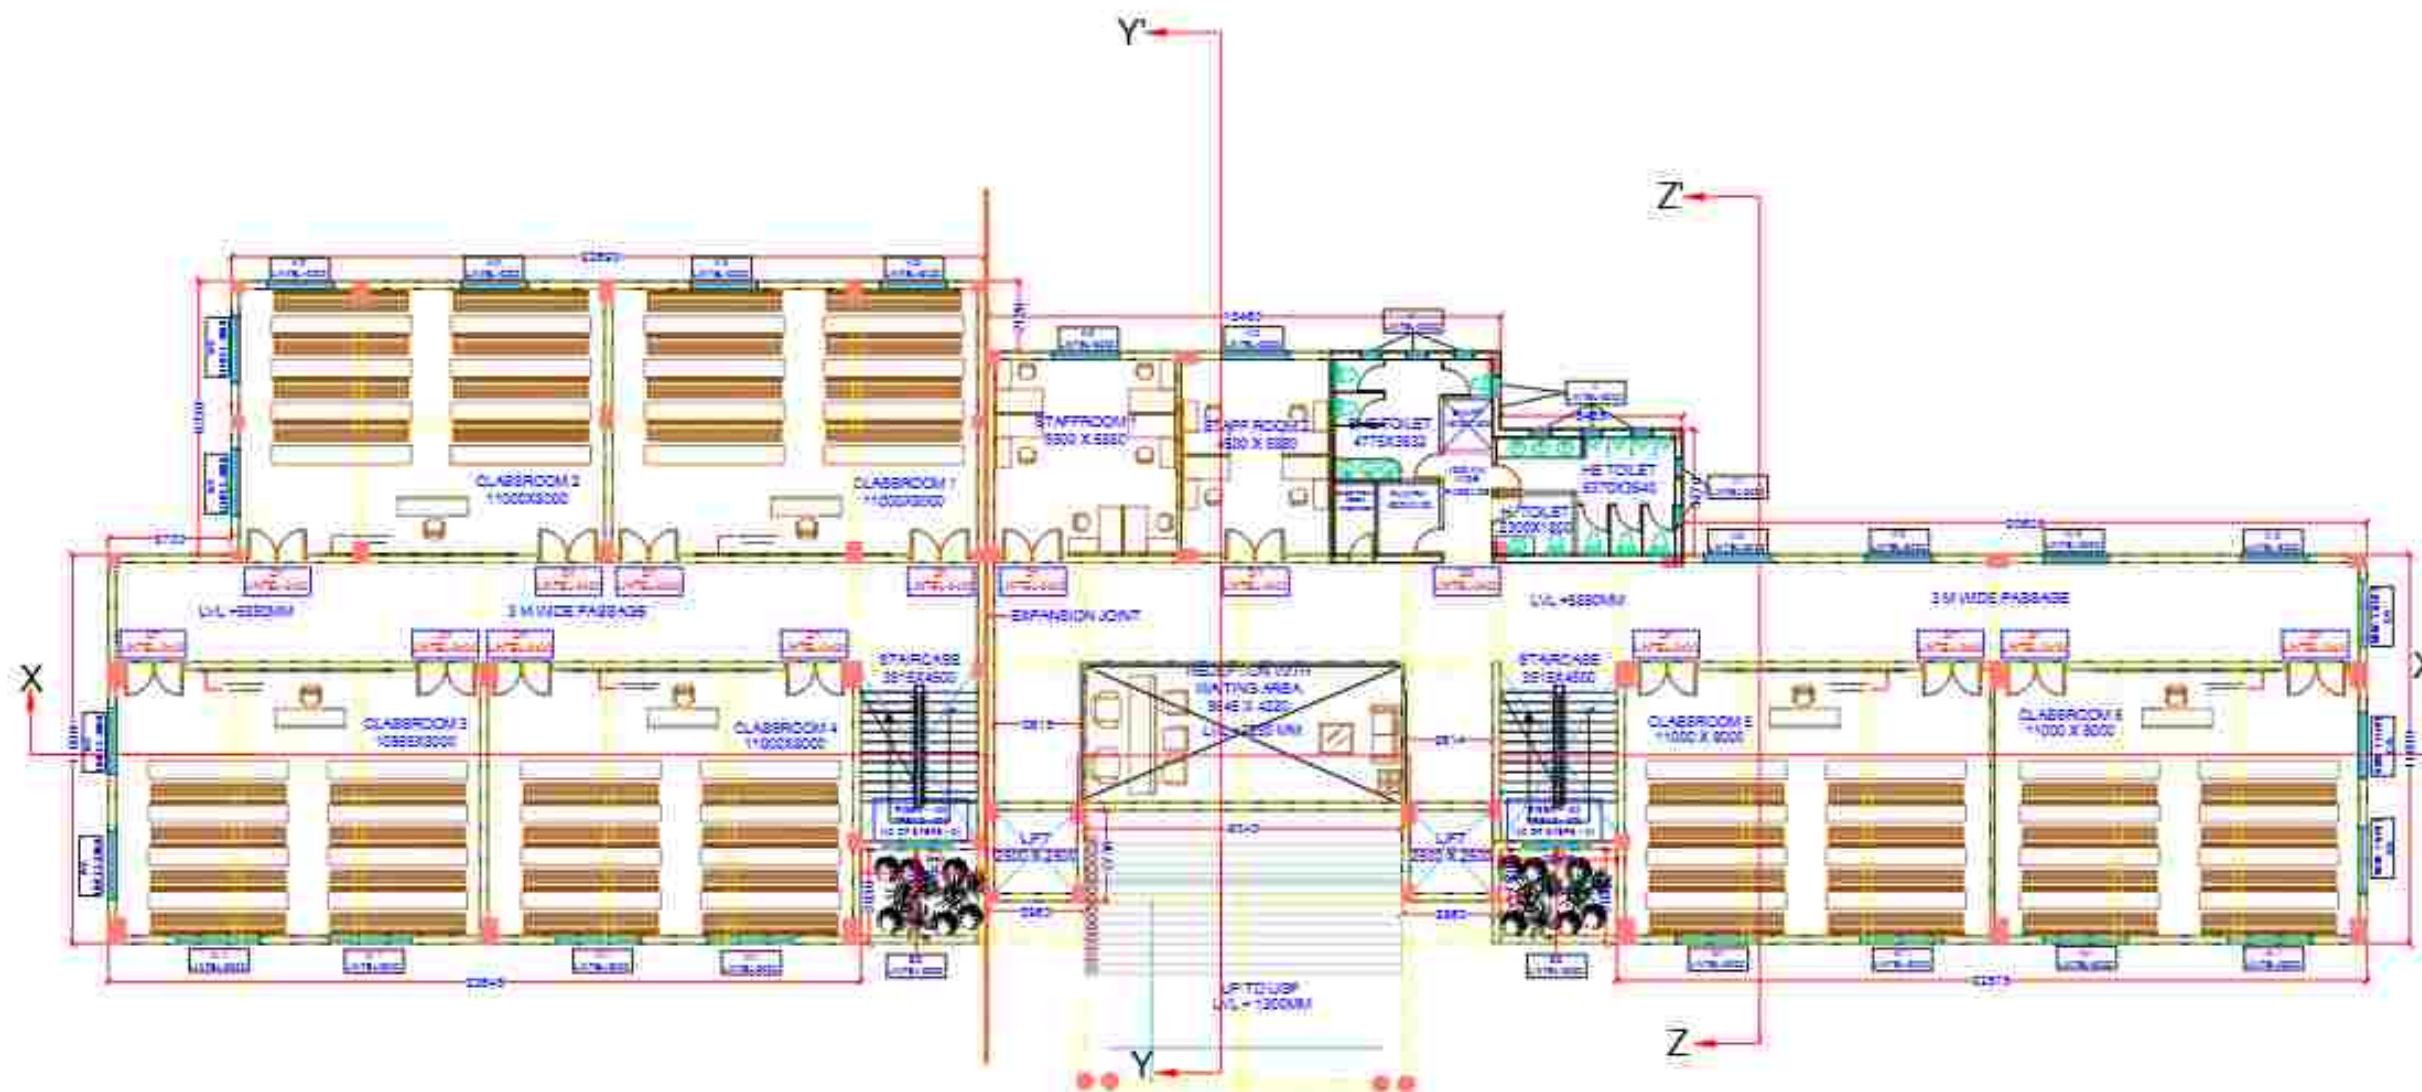

FIRST FLOOR (1:300)

Architectural Consultant
Ar. Gaurav Gupta

Structural Consultant
SBS Consultant

Electrical Consultant
Plumbing Consultant

Client/Owner
BHARAT SEWA SANSTHAN

Project Description
CHANDRABHAN GUPT LAW
COLLEGE


North

Drawing Title
SECOND FLOOR DOOR - WINDOW MARKING

Date:- 25/03/2025
Drawn By:- SANA
Checked By:- AR. Gaurav Gupta
Scale:- N.T.S

Project Code:-
Sheet No:-


Office Stamp

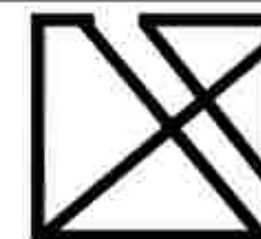

DE: CA+PE STUDIO

Collaborative Architecture & Planning Environment

Head Office - L2-155, Sector G, LDA colony, Ashiyana
Kanpur Road near Roy Hospital, behind Spring Dale
School, Lucknow - 226012
Branch Office - 8/1, Basement, Kalkaji extension,
Delhi - 110019
Contact no - +91 99350 05439
E-Mail- studio.decape18@gmail.com
info.decapestudio@gmail.com

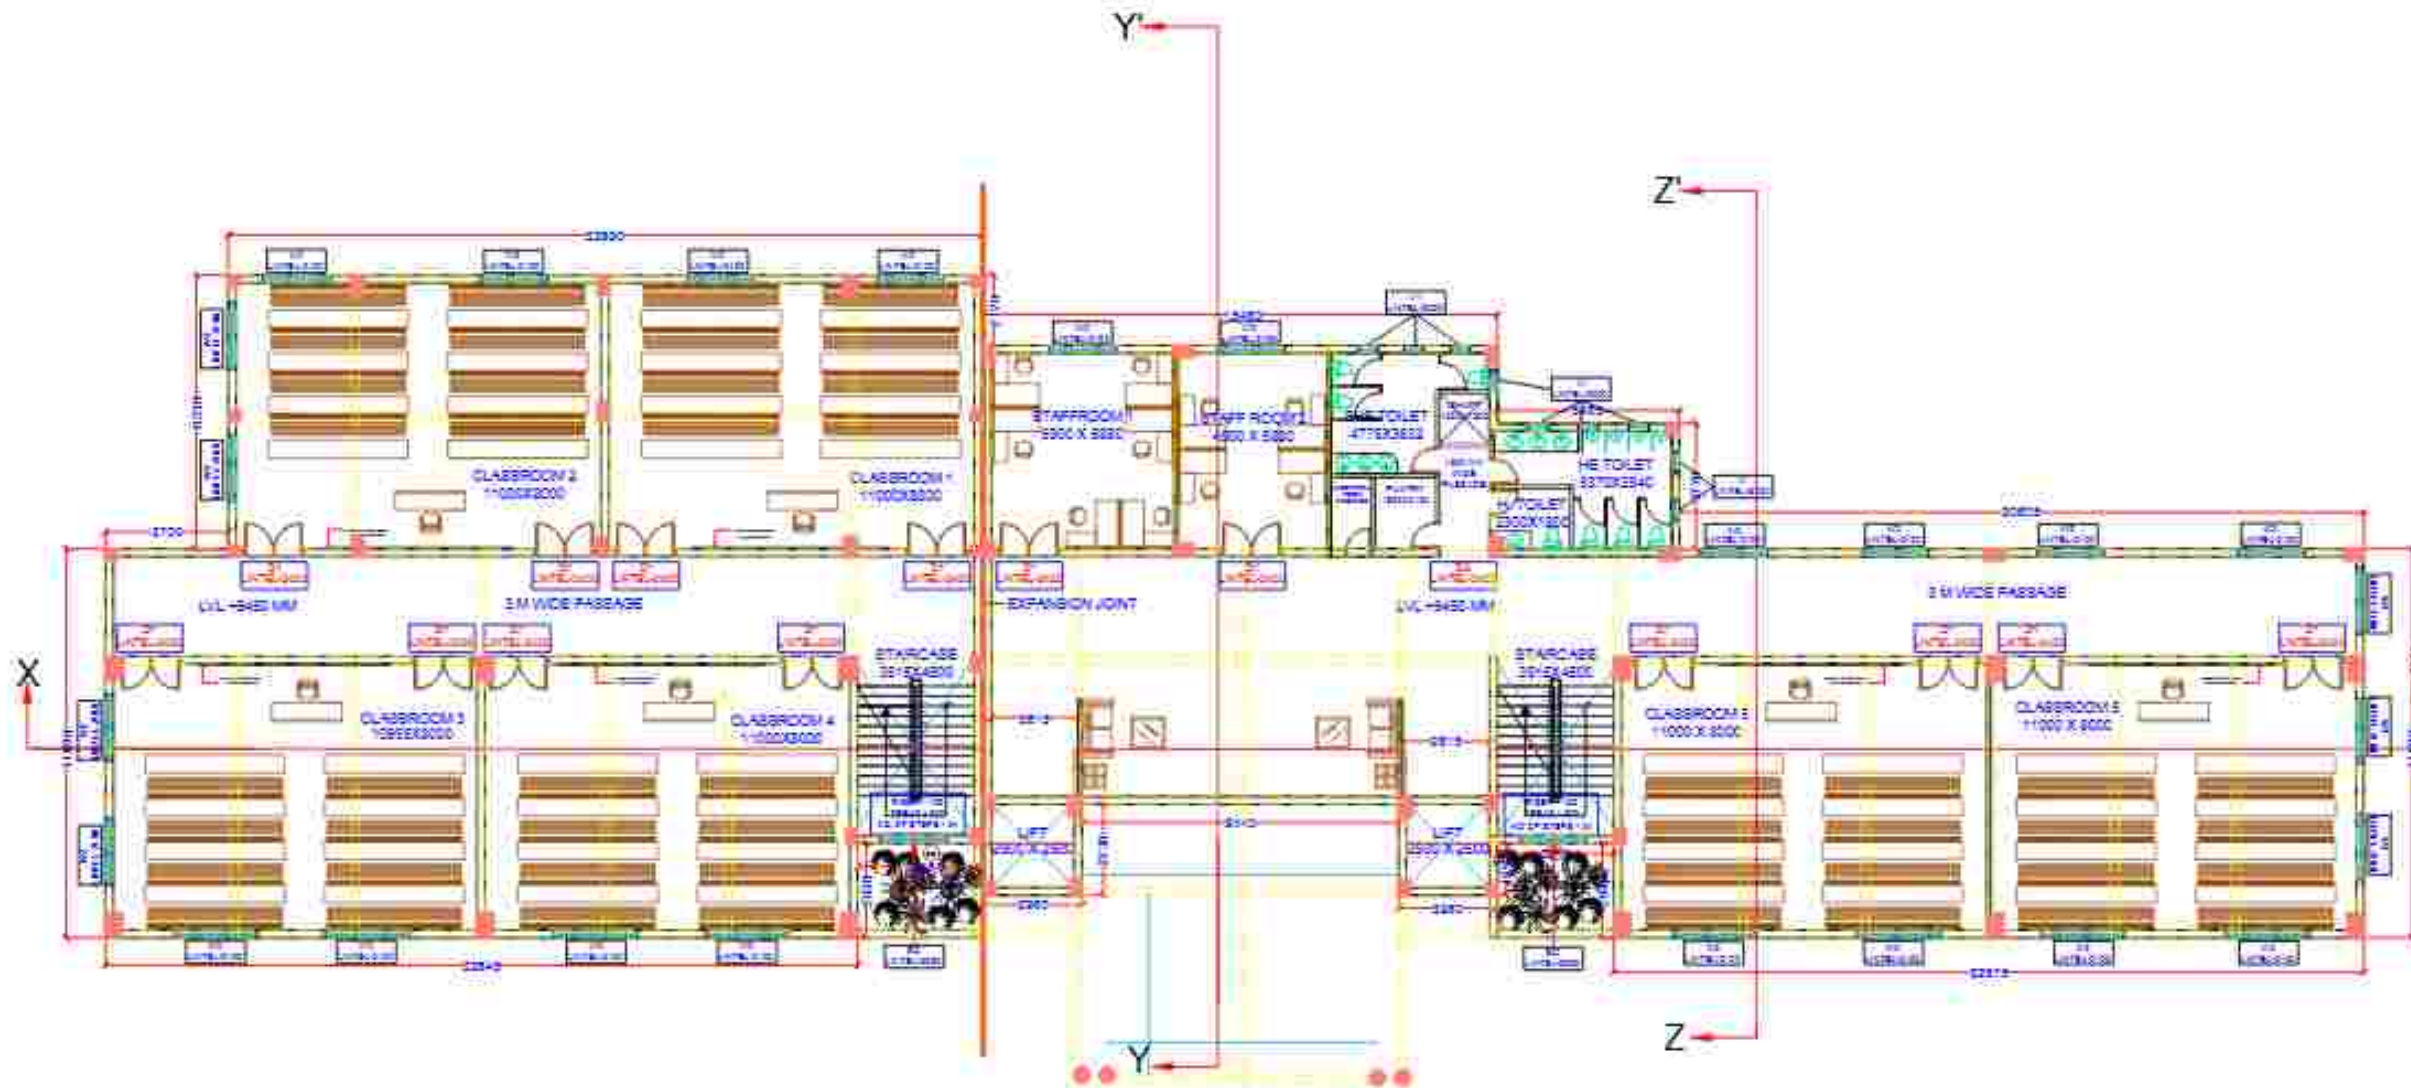

SECOND FLOOR (1:300)

NOTE:

1. This drawing is a property of De:Ca+Pe Studio and is not to be reproduced copied or handed over in any form except for the purpose for which it is intended.
2. All dimension are in Millimeter except where mentioned.
3. Drawings are not to be scaled written dimensions are to be followed.
4. All discrepancies to be brought to the notice of the Architect and resolved before commencement of any work.

Architectural Consultant: Ar. Gaurav Gupta

Structural Consultant: SRS Consultant

Electrical Consultant: Plumbing Consultant

Client/Owner: BHARAT SEWA SANSTHAN

Project Description: CHANDRABHAN GUPTA LAW COLLEGE


North

Drawing Title: SECOND FLOOR DOOR - WINDOW MARKING

Date: 25/03/2025
Drawn By: SANA
Checked By: AR. Gaurav Gupta
Scale: N.T.S

Project Code:
Sheet No.:


Office Stamp

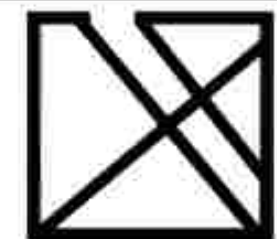

DE: CA+PE STUDIO

Collaborative Architecture & Planning Environment

Head Office - L2-155, Sector G, LDA colony, Astiyana
Kanpur Road near Roy Hospital, behind Spring Dale
School, Lucknow - 226012
Branch Office - 8/1, Basement, Kalkaji extension,
Delhi - 110019
Contact no - +91 99350 05439
E-Mail- studio.decape18@gmail.com
info.decapestudio@gmail.com

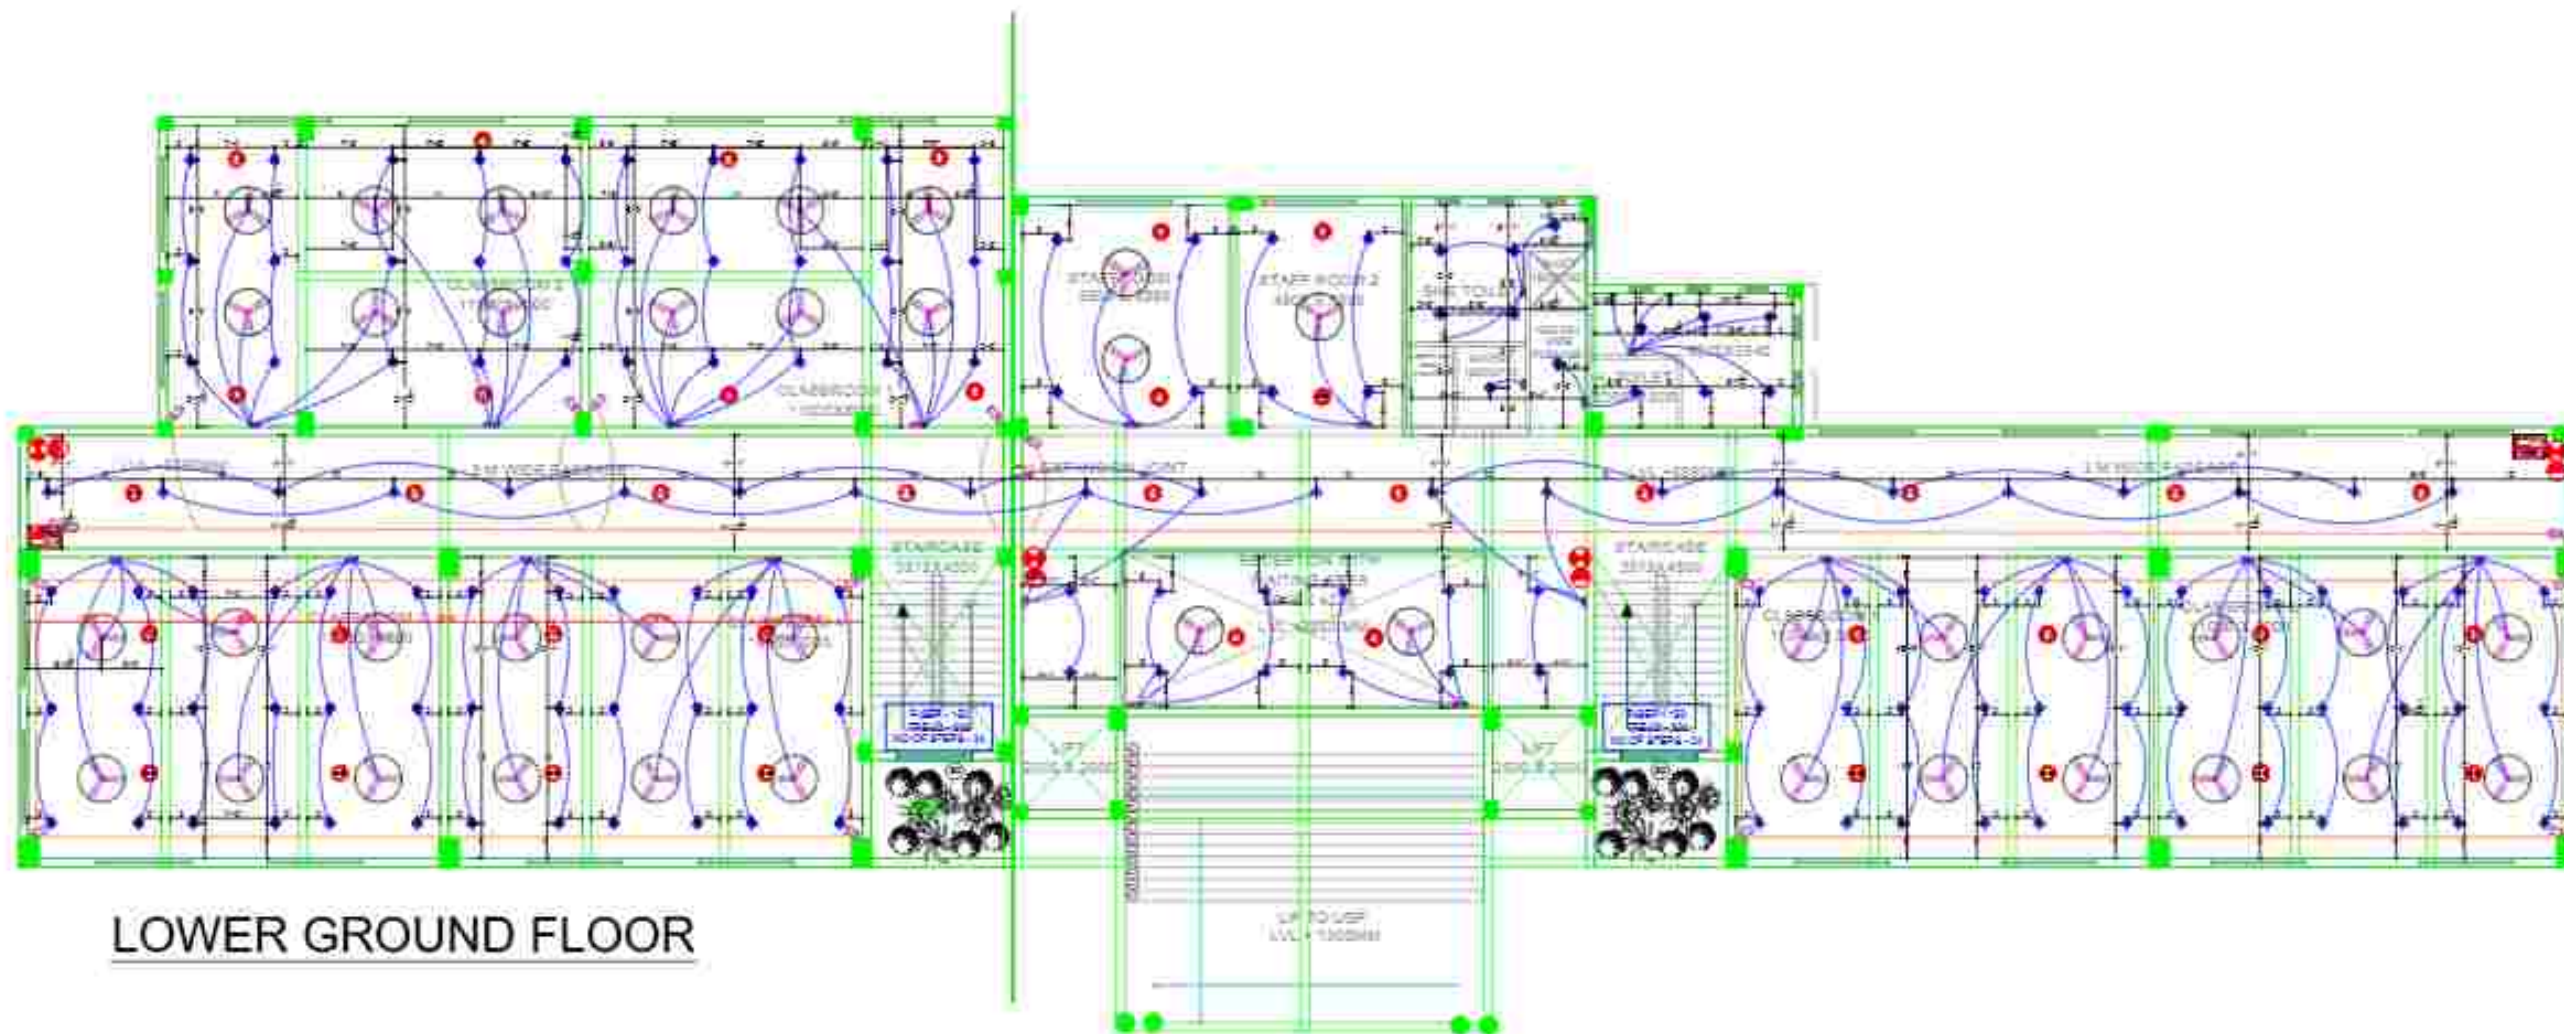

LOWER GROUND FLOOR



LOWER GROUND FLOOR

NOTE:

1. Work during the progress of 2023-24 study was as per the approved layout in hand.
2. All dimensions are in meters except where mentioned.
3. Drawings are subject to change without notice.
4. All dimensions are to be brought to the notice of the Architect and verified before construction of any work.

OWNER / CLIENT:

RAJ BHAWAN

ARCHITECTURAL CONSULTANT:

AR. GAURAV GUPTA

DRAWING TITLE:

LAW COLLEGE-
ELECTRICAL
(UPPER GROUND FLOOR)

NORTH:-

DRAWN BY: AR. MOHD. HASI

SCALE: N.T.S

CHKD BY: AR. GAURAV GUPTA

DATE: 07-03-2023


OFFICE STAMP:




DE: CA+PE STUDIO

1A - 2B, MIDC, 1ST FLOOR, ANDHRA PRADESH, HYDRABAD - 500015

MOBILE: 9849000000
TEL: 020-26666666
WWW.CA+PESTUDIO.COM

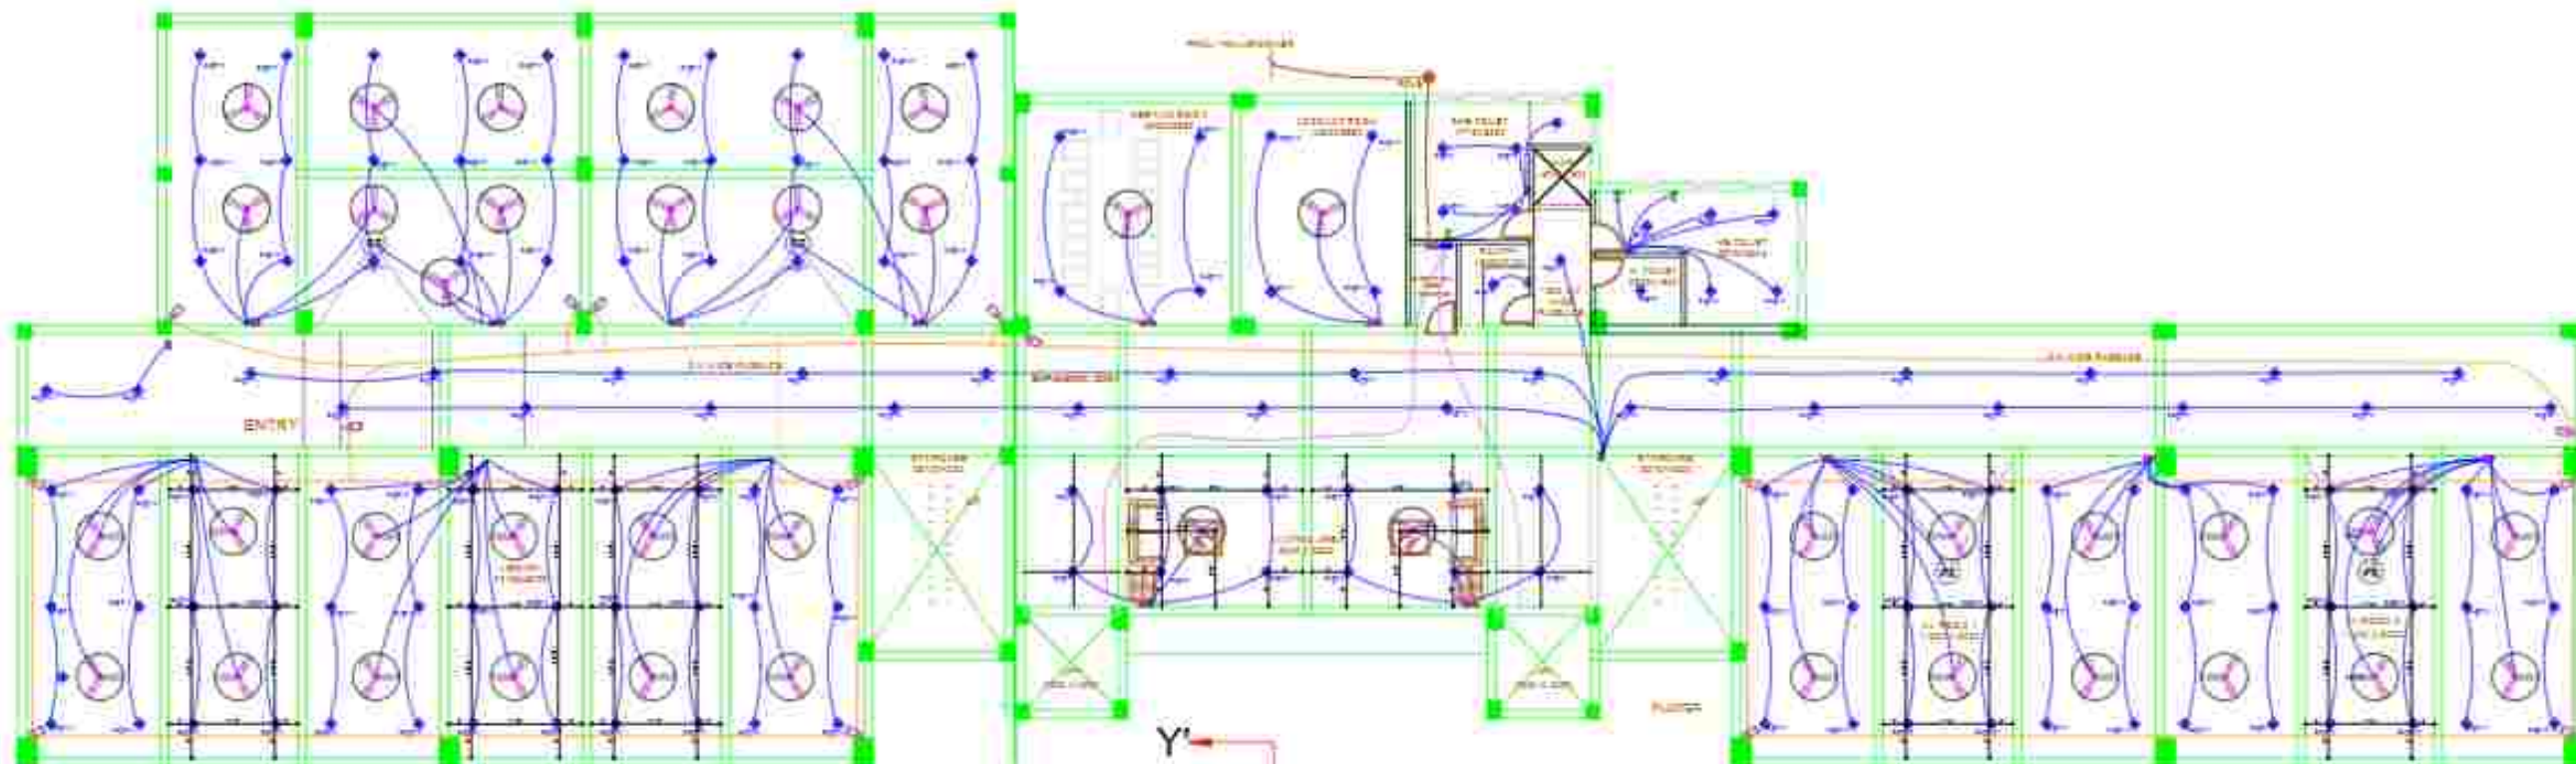

UPPER GROUND FLOOR

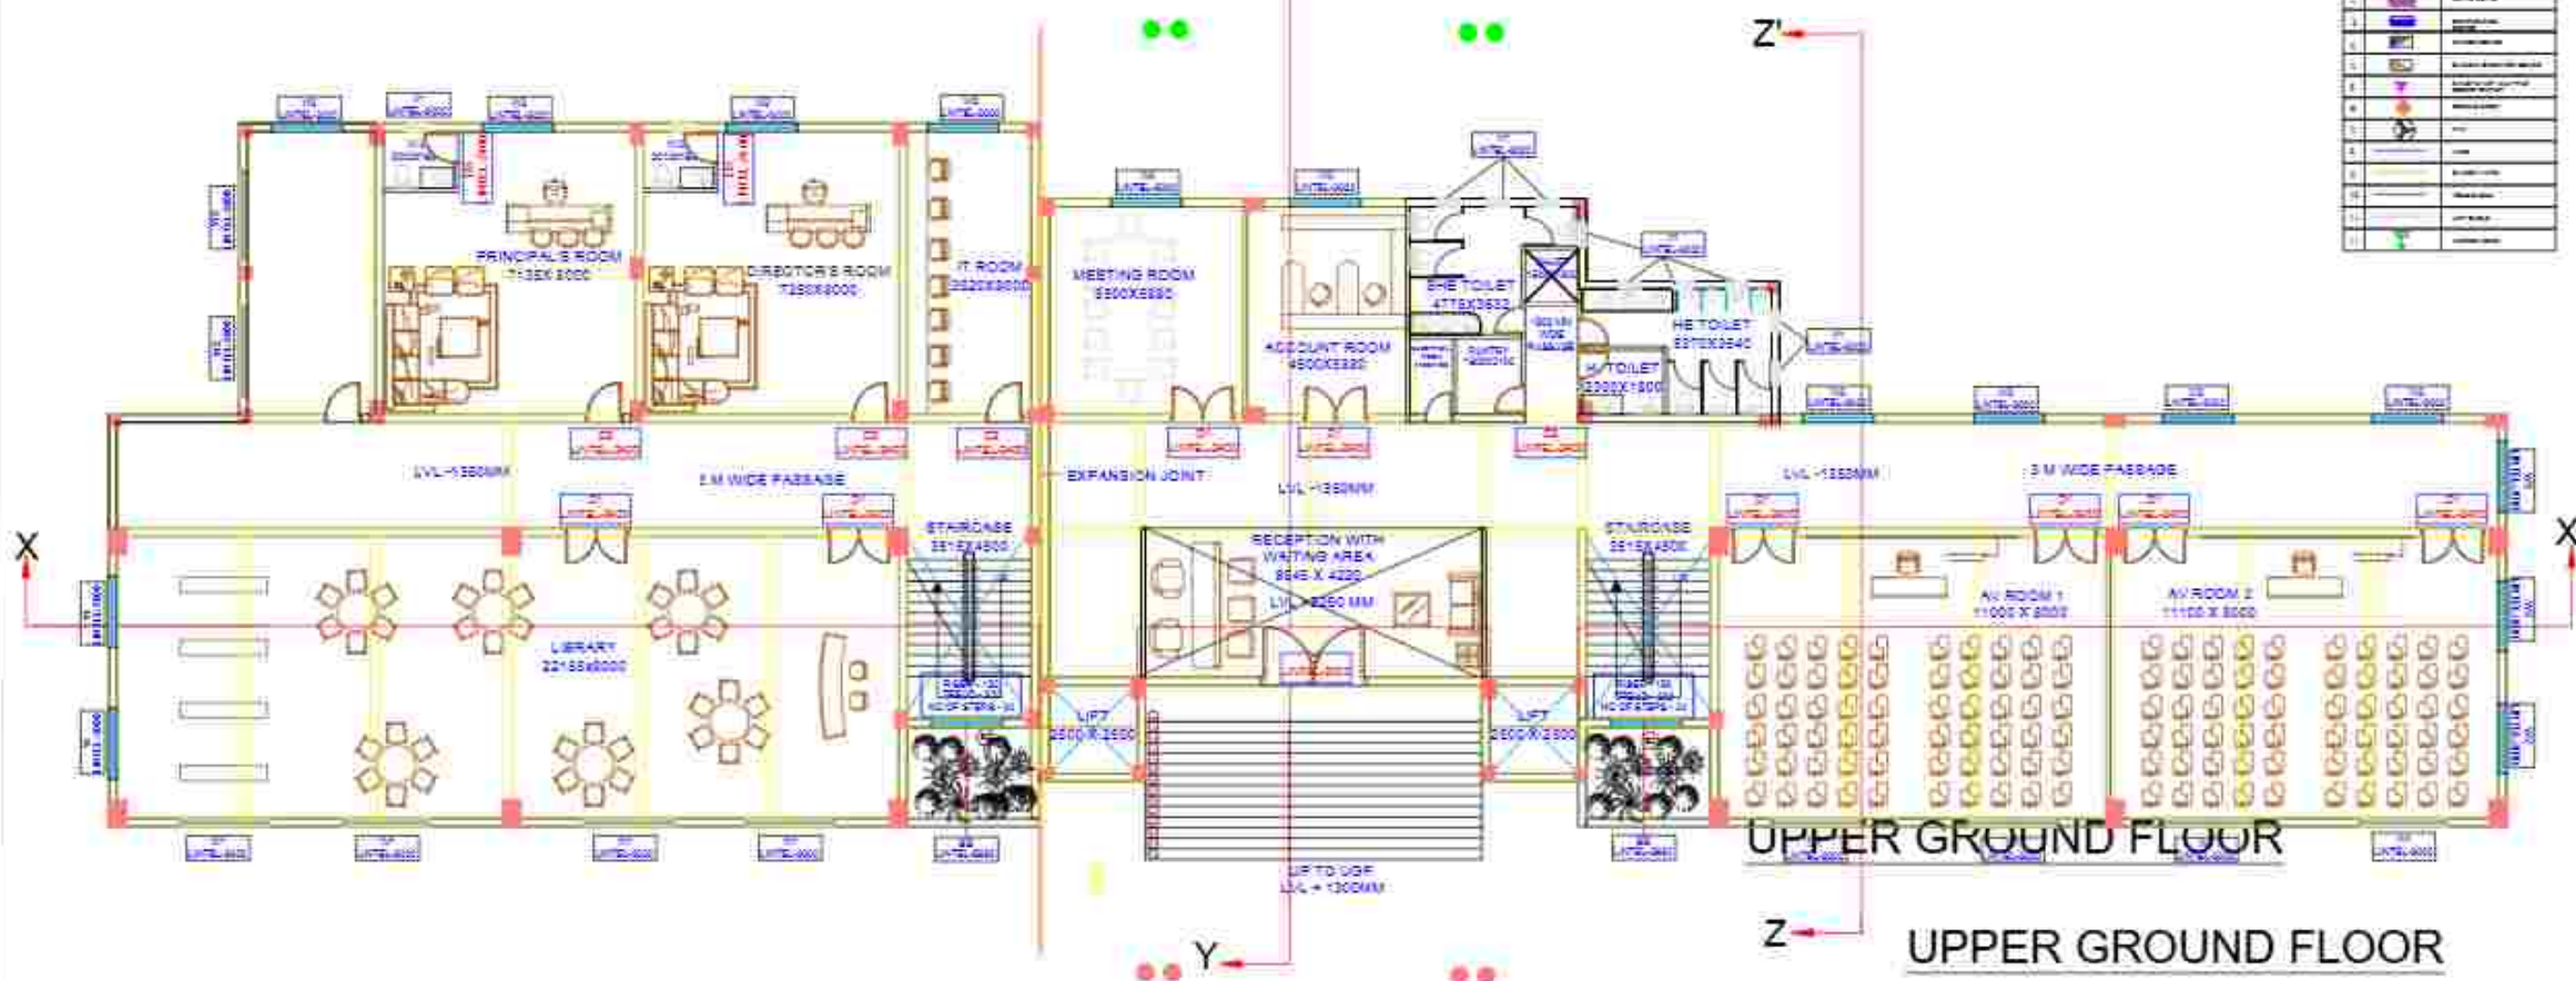

UPPER GROUND FLOOR

UPPER GROUND FLOOR

NOTE:
1. All drawings are prepared by CA+PE Studio and are not to be used for any other purpose without the written consent of the studio.
2. All dimensions are in meters unless otherwise specified.
3. All drawings are to be made in accordance with the Indian Standards.
4. All drawings are to be made in accordance with the Indian Standards.
5. All drawings are to be made in accordance with the Indian Standards.

OWNER / CLIENT:
RAJ BHAWAN

ARCHITECTURAL CONSULTANT:
AR. GAURAV GUPTA

DRAWING TITLE:
LAW COLLEGE-
ELECTRICAL
(UPPER GROUND FLOOR)


NORTH:-

DRAWN BY: AR. MOH. HASAN
SCALE: N.T.S.
CHKD BY: AR. GAURAV GUPTA
DATE: 07-03-2023

OFFICE STAMP:




DE: CA+PE STUDIO
COLLECTION & ARCHITECTURE & PLANNING
1A - 1B, 1C, 1D, 1E, 1F, 1G, 1H, 1I, 1J, 1K, 1L, 1M, 1N, 1O, 1P, 1Q, 1R, 1S, 1T, 1U, 1V, 1W, 1X, 1Y, 1Z, 1AA, 1AB, 1AC, 1AD, 1AE, 1AF, 1AG, 1AH, 1AI, 1AJ, 1AK, 1AL, 1AM, 1AN, 1AO, 1AP, 1AQ, 1AR, 1AS, 1AT, 1AU, 1AV, 1AW, 1AX, 1AY, 1AZ, 1BA, 1BB, 1BC, 1BD, 1BE, 1BF, 1BG, 1BH, 1BI, 1BJ, 1BK, 1BL, 1BM, 1BN, 1BO, 1BP, 1BQ, 1BR, 1BS, 1BT, 1BU, 1BV, 1BW, 1BX, 1BY, 1BZ, 1CA, 1CB, 1CC, 1CD, 1CE, 1CF, 1CG, 1CH, 1CI, 1CJ, 1CK, 1CL, 1CM, 1CN, 1CO, 1CP, 1CQ, 1CR, 1CS, 1CT, 1CU, 1CV, 1CW, 1CX, 1CY, 1CZ, 1DA, 1DB, 1DC, 1DD, 1DE, 1DF, 1DG, 1DH, 1DI, 1DJ, 1DK, 1DL, 1DM, 1DN, 1DO, 1DP, 1DQ, 1DR, 1DS, 1DT, 1DU, 1DV, 1DW, 1DX, 1DY, 1DZ, 1EA, 1EB, 1EC, 1ED, 1EE, 1EF, 1EG, 1EH, 1EI, 1EJ, 1EK, 1EL, 1EM, 1EN, 1EO, 1EP, 1EQ, 1ER, 1ES, 1ET, 1EU, 1EV, 1EW, 1EX, 1EY, 1EZ, 1FA, 1FB, 1FC, 1FD, 1FE, 1FF, 1FG, 1FH, 1FI, 1FJ, 1FK, 1FL, 1FM, 1FN, 1FO, 1FP, 1FQ, 1FR, 1FS, 1FT, 1FU, 1FV, 1FW, 1FX, 1FY, 1FZ, 1GA, 1GB, 1GC, 1GD, 1GE, 1GF, 1GG, 1GH, 1GI, 1GJ, 1GK, 1GL, 1GM, 1GN, 1GO, 1GP, 1GQ, 1GR, 1GS, 1GT, 1GU, 1GV, 1GW, 1GX, 1GY, 1GZ, 1HA, 1HB, 1HC, 1HD, 1HE, 1HF, 1HG, 1HH, 1HI, 1HJ, 1HK, 1HL, 1HM, 1HN, 1HO, 1HP, 1HQ, 1HR, 1HS, 1HT, 1HU, 1HV, 1HW, 1HX, 1HY, 1HZ, 1IA, 1IB, 1IC, 1ID, 1IE, 1IF, 1IG, 1IH, 1II, 1IJ, 1IK, 1IL, 1IM, 1IN, 1IO, 1IP, 1IQ, 1IR, 1IS, 1IT, 1IU, 1IV, 1IW, 1IX, 1IY, 1IZ, 1JA, 1JB, 1JC, 1JD, 1JE, 1JF, 1JG, 1JH, 1JI, 1JJ, 1JK, 1JL, 1JM, 1JN, 1JO, 1JP, 1JQ, 1JR, 1JS, 1JT, 1JU, 1JV, 1JW, 1JX, 1JY, 1JZ, 1KA, 1KB, 1KC, 1KD, 1KE, 1KF, 1KG, 1KH, 1KI, 1KJ, 1KK, 1KL, 1KM, 1KN, 1KO, 1KP, 1KQ, 1KR, 1KS, 1KT, 1KU, 1KV, 1KW, 1KX, 1KY, 1KZ, 1LA, 1LB, 1LC, 1LD, 1LE, 1LF, 1LG, 1LH, 1LI, 1LJ, 1LK, 1LL, 1LM, 1LN, 1LO, 1LP, 1LQ, 1LR, 1LS, 1LT, 1LU, 1LV, 1LW, 1LX, 1LY, 1LZ, 1MA, 1MB, 1MC, 1MD, 1ME, 1MF, 1MG, 1MH, 1MI, 1MJ, 1MK, 1ML, 1MM, 1MN, 1MO, 1MP, 1MQ, 1MR, 1MS, 1MT, 1MU, 1MV, 1MW, 1MX, 1MY, 1MZ, 1NA, 1NB, 1NC, 1ND, 1NE, 1NF, 1NG, 1NH, 1NI, 1NJ, 1NK, 1NL, 1NM, 1NN, 1NO, 1NP, 1NQ, 1NR, 1NS, 1NT, 1NU, 1NV, 1NW, 1NX, 1NY, 1NZ, 1OA, 1OB, 1OC, 1OD, 1OE, 1OF, 1OG, 1OH, 1OI, 1OJ, 1OK, 1OL, 1OM, 1ON, 1OO, 1OP, 1OQ, 1OR, 1OS, 1OT, 1OU, 1OV, 1OW, 1OX, 1OY, 1OZ, 1PA, 1PB, 1PC, 1PD, 1PE, 1PF, 1PG, 1PH, 1PI, 1PJ, 1PK, 1PL, 1PM, 1PN, 1PO, 1PP, 1PQ, 1PR, 1PS, 1PT, 1PU, 1PV, 1PW, 1PX, 1PY, 1PZ, 1QA, 1QB, 1QC, 1QD, 1QE, 1QF, 1QG, 1QH, 1QI, 1QJ, 1QK, 1QL, 1QM, 1QN, 1QO, 1QP, 1QQ, 1QR, 1QS, 1QT, 1QU, 1QV, 1QW, 1QX, 1QY, 1QZ, 1RA, 1RB, 1RC, 1RD, 1RE, 1RF, 1RG, 1RH, 1RI, 1RJ, 1RK, 1RL, 1RM, 1RN, 1RO, 1RP, 1RQ, 1RR, 1RS, 1RT, 1RU, 1RV, 1RW, 1RX, 1RY, 1RZ, 1SA, 1SB, 1SC, 1SD, 1SE, 1SF, 1SG, 1SH, 1SI, 1SJ, 1SK, 1SL, 1SM, 1SN, 1SO, 1SP, 1SQ, 1SR, 1SS, 1ST, 1SU, 1SV, 1SW, 1SX, 1SY, 1SZ, 1TA, 1TB, 1TC, 1TD, 1TE, 1TF, 1TG, 1TH, 1TI, 1TJ, 1TK, 1TL, 1TM, 1TN, 1TO, 1TP, 1TQ, 1TR, 1TS, 1TT, 1TU, 1TV, 1TW, 1TX, 1TY, 1TZ, 1UA, 1UB, 1UC, 1UD, 1UE, 1UF, 1UG, 1UH, 1UI, 1UJ, 1UK, 1UL, 1UM, 1UN, 1UO, 1UP, 1UQ, 1UR, 1US, 1UT, 1UU, 1UV, 1UW, 1UX, 1UY, 1UZ, 1VA, 1VB, 1VC, 1VD, 1VE, 1VF, 1VG, 1VH, 1VI, 1VJ, 1VK, 1VL, 1VM, 1VN, 1VO, 1VP, 1VQ, 1VR, 1VS, 1VT, 1VU, 1VV, 1VW, 1VX, 1VY, 1VZ, 1WA, 1WB, 1WC, 1WD, 1WE, 1WF, 1WG, 1WH, 1WI, 1WJ, 1WK, 1WL, 1WM, 1WN, 1WO, 1WP, 1WQ, 1WR, 1WS, 1WT, 1WU, 1WV, 1WW, 1WX, 1WY, 1WZ, 1XA, 1XB, 1XC, 1XD, 1XE, 1XF, 1XG, 1XH, 1XI, 1XJ, 1XK, 1XL, 1XM, 1XN, 1XO, 1XP, 1XQ, 1XR, 1XS, 1XT, 1XU, 1XV, 1XW, 1XX, 1XY, 1XZ, 1YA, 1YB, 1YC, 1YD, 1YE, 1YF, 1YG, 1YH, 1YI, 1YJ, 1YK, 1YL, 1YM, 1YN, 1YO, 1YP, 1YQ, 1YR, 1YS, 1YT, 1YU, 1YV, 1YW, 1YX, 1YY, 1YZ, 1ZA, 1ZB, 1ZC, 1ZD, 1ZE, 1ZF, 1ZG, 1ZH, 1ZI, 1ZJ, 1ZK, 1ZL, 1ZM, 1ZN, 1ZO, 1ZP, 1ZQ, 1ZR, 1ZS, 1ZT, 1ZU, 1ZV, 1ZW, 1ZX, 1ZY, 1ZZ, 2AA, 2AB, 2AC, 2AD, 2AE, 2AF, 2AG, 2AH, 2AI, 2AJ, 2AK, 2AL, 2AM, 2AN, 2AO, 2AP, 2AQ, 2AR, 2AS, 2AT, 2AU, 2AV, 2AW, 2AX, 2AY, 2AZ, 2BA, 2BB, 2BC, 2BD, 2BE, 2BF, 2BG, 2BH, 2BI, 2BJ, 2BK, 2BL, 2BM, 2BN, 2BO, 2BP, 2BQ, 2BR, 2BS, 2BT, 2BU, 2BV, 2BW, 2BX, 2BY, 2BZ, 2CA, 2CB, 2CC, 2CD, 2CE, 2CF, 2CG, 2CH, 2CI, 2CJ, 2CK, 2CL, 2CM, 2CN, 2CO, 2CP, 2CQ, 2CR, 2CS, 2CT, 2CU, 2CV, 2CW, 2CX, 2CY, 2CZ, 2DA, 2DB, 2DC, 2DD, 2DE, 2DF, 2DG, 2DH, 2DI, 2DJ, 2DK, 2DL, 2DM, 2DN, 2DO, 2DP, 2DQ, 2DR, 2DS, 2DT, 2DU, 2DV, 2DW, 2DX, 2DY, 2DZ, 2EA, 2EB, 2EC, 2ED, 2EE, 2EF, 2EG, 2EH, 2EI, 2EJ, 2EK, 2EL, 2EM, 2EN, 2EO, 2EP, 2EQ, 2ER, 2ES, 2ET, 2EU, 2EV, 2EW, 2EX, 2EY, 2EZ, 2FA, 2FB, 2FC, 2FD, 2FE, 2FF, 2FG, 2FH, 2FI, 2FJ, 2FK, 2FL, 2FM, 2FN, 2FO, 2FP, 2FQ, 2FR, 2FS, 2FT, 2FU, 2FV, 2FW, 2FX, 2FY, 2FZ, 2GA, 2GB, 2GC, 2GD, 2GE, 2GF, 2GG, 2GH, 2GI, 2GJ, 2GK, 2GL, 2GM, 2GN, 2GO, 2GP, 2GQ, 2GR, 2GS, 2GT, 2GU, 2GV, 2GW, 2GX, 2GY, 2GZ, 2HA, 2HB, 2HC, 2HD, 2HE, 2HF, 2HG, 2HH, 2HI, 2HJ, 2HK, 2HL, 2HM, 2HN, 2HO, 2HP, 2HQ, 2HR, 2HS, 2HT, 2HU, 2HV, 2HW, 2HX, 2HY, 2HZ, 2IA, 2IB, 2IC, 2ID, 2IE, 2IF, 2IG, 2IH, 2II, 2IJ, 2IK, 2IL, 2IM, 2IN, 2IO, 2IP, 2IQ, 2IR, 2IS, 2IT, 2IU, 2IV, 2IW, 2IX, 2IY, 2IZ, 2JA, 2JB, 2JC, 2JD, 2JE, 2JF, 2JG, 2JH, 2JI, 2JJ, 2JK, 2JL, 2JM, 2JN, 2JO, 2JP, 2JQ, 2JR, 2JS, 2JT, 2JU, 2JV, 2JW, 2JX, 2JY, 2JZ, 2KA, 2KB, 2KC, 2KD, 2KE, 2KF, 2KG, 2KH, 2KI, 2KJ, 2KK, 2KL, 2KM, 2KN, 2KO, 2KP, 2KQ, 2KR, 2KS, 2KT, 2KU, 2KV, 2KW, 2KX, 2KY, 2KZ, 2LA, 2LB, 2LC, 2LD, 2LE, 2LF, 2LG, 2LH, 2LI, 2LJ, 2LK, 2LM, 2LN, 2LO, 2LP, 2LQ, 2LR, 2LS, 2LT, 2LU, 2LV, 2LW, 2LX, 2LY, 2LZ, 2MA, 2MB, 2MC, 2MD, 2ME, 2MF, 2MG, 2MH, 2MI, 2MJ, 2MK, 2ML, 2MM, 2MN, 2MO, 2MP, 2MQ, 2MR, 2MS, 2MT, 2MU, 2MV, 2MW, 2MX, 2MY, 2MZ, 2NA, 2NB, 2NC, 2ND, 2NE, 2NF, 2NG, 2NH, 2NI, 2NJ, 2NK, 2NL, 2NM, 2NN, 2NO, 2NP, 2NQ, 2NR, 2NS, 2NT, 2NU, 2NV, 2NW, 2NX, 2NY, 2NZ, 2OA, 2OB, 2OC, 2OD, 2OE, 2OF, 2OG, 2OH, 2OI, 2OJ, 2OK, 2OL, 2OM, 2ON, 2OO, 2OP, 2OQ, 2OR, 2OS, 2OT, 2OU, 2OV, 2OW, 2OX, 2OY, 2OZ, 2PA, 2PB, 2PC, 2PD, 2PE, 2PF, 2PG, 2PH, 2PI, 2PJ, 2PK, 2PL, 2PM, 2PN, 2PO, 2PP, 2PQ, 2PR, 2PS, 2PT, 2PU, 2PV, 2PW, 2PX, 2PY, 2PZ, 2QA, 2QB, 2QC, 2QD, 2QE, 2QF, 2QG, 2QH, 2QI, 2QJ, 2QK, 2QL, 2QM, 2QN, 2QO, 2QP, 2QQ, 2QR, 2QS, 2QT, 2QU, 2QV, 2QW, 2QX, 2QY, 2QZ, 2RA, 2RB, 2RC, 2RD, 2RE, 2RF, 2RG, 2RH, 2RI, 2RJ, 2RK, 2RL, 2RM, 2RN, 2RO, 2RP, 2RQ, 2RR, 2RS, 2RT, 2RU, 2RV, 2RW, 2RX, 2RY, 2RZ, 2SA, 2SB, 2SC, 2SD, 2SE, 2SF, 2SG, 2SH, 2SI, 2SJ, 2SK, 2SL, 2SM, 2SN, 2SO, 2SP, 2SQ, 2SR, 2SS, 2ST, 2SU, 2SV, 2SW, 2SX, 2SY, 2SZ, 2TA, 2TB, 2TC, 2TD, 2TE, 2TF, 2TG, 2TH, 2TI, 2TJ, 2TK, 2TL, 2TM, 2TN, 2TO, 2TP, 2TQ, 2TR, 2TS, 2TT, 2TU, 2TV, 2TW, 2TX, 2TY, 2TZ, 2UA, 2UB, 2UC, 2UD, 2UE, 2UF, 2UG, 2UH, 2UI, 2UJ, 2UK, 2UL, 2UM, 2UN, 2UO, 2UP, 2UQ, 2UR, 2US, 2UT, 2UU, 2UV, 2UW, 2UX, 2UY, 2UZ, 2VA, 2VB, 2VC, 2VD, 2VE, 2VF, 2VG, 2VH, 2VI, 2VJ, 2VK, 2VL, 2VM, 2VN, 2VO, 2VP, 2VQ, 2VR, 2VS, 2VT, 2VU, 2VV, 2VW, 2VX, 2VY, 2VZ, 2WA, 2WB, 2WC, 2WD, 2WE, 2WF, 2WG, 2WH, 2WI, 2WJ, 2WK, 2WL, 2WM, 2WN, 2WO, 2WP, 2WQ, 2WR, 2WS, 2WT, 2WU, 2WV, 2WW, 2WX, 2WY, 2WZ, 2XA, 2XB, 2XC, 2XD, 2XE, 2XF, 2XG, 2XH, 2XI, 2XJ, 2XK, 2XL, 2XM, 2XN, 2XO, 2XP, 2XQ, 2XR, 2XS, 2XT, 2XU, 2XV, 2XW, 2XX, 2XY, 2XZ, 2YA, 2YB, 2YC, 2YD, 2YE, 2YF, 2YG, 2YH, 2YI, 2YJ, 2YK, 2YL, 2YM, 2YN, 2YO, 2YP, 2YQ, 2YR, 2YS, 2YT, 2YU, 2YV, 2YW, 2YX, 2YY, 2YZ, 2ZA, 2ZB, 2ZC, 2ZD, 2ZE, 2ZF, 2ZG, 2ZH, 2ZI, 2ZJ, 2ZK, 2ZL, 2ZM, 2ZN, 2ZO, 2ZP, 2ZQ, 2ZR, 2ZS, 2ZT, 2ZU, 2ZV, 2ZW, 2ZX, 2ZY, 2ZZ, 3AA, 3AB, 3AC, 3AD, 3AE, 3AF, 3AG, 3AH, 3AI, 3AJ, 3AK, 3AL, 3AM, 3AN, 3AO, 3AP, 3AQ, 3AR, 3AS, 3AT, 3AU, 3AV, 3AW, 3AX, 3AY, 3AZ, 3BA, 3BB, 3BC, 3BD, 3BE, 3BF, 3BG, 3BH, 3BI, 3BJ, 3BK, 3BL, 3BM, 3BN, 3BO, 3BP, 3BQ, 3BR, 3BS, 3BT, 3BU, 3BV, 3BW, 3BX, 3BY, 3BZ, 3CA, 3CB, 3CC, 3CD, 3CE, 3CF, 3CG, 3CH, 3CI, 3CJ, 3CK, 3CL, 3CM, 3CN, 3CO, 3CP, 3CQ, 3CR, 3CS, 3CT, 3CU, 3CV, 3CW, 3CX, 3CY, 3CZ, 3DA, 3DB, 3DC, 3DD, 3DE, 3DF, 3DG, 3DH, 3DI, 3DJ, 3DK, 3DL, 3DM, 3DN, 3DO, 3DP, 3DQ, 3DR, 3DS, 3DT, 3DU, 3DV, 3DW, 3DX, 3DY, 3DZ, 3EA, 3EB, 3EC, 3ED, 3EE, 3EF, 3EG, 3EH, 3EI, 3EJ, 3EK, 3EL, 3EM, 3EN, 3EO, 3EP, 3EQ, 3ER, 3ES, 3ET, 3EU, 3EV, 3EW, 3EX, 3EY, 3EZ, 3FA, 3FB, 3FC, 3FD, 3FE, 3FF, 3FG, 3FH, 3FI, 3FJ, 3FK, 3FL, 3FM, 3FN, 3FO, 3FP, 3FQ, 3FR, 3FS, 3FT, 3FU, 3FV, 3FW, 3FX, 3FY, 3FZ, 3GA, 3GB, 3GC, 3GD, 3GE, 3GF, 3GG, 3GH, 3GI, 3GJ, 3GK, 3GL, 3GM, 3GN, 3GO, 3GP, 3GQ, 3GR, 3GS, 3GT, 3GU, 3GV, 3GW, 3GX, 3GY, 3GZ, 3HA, 3HB, 3HC, 3HD, 3HE, 3HF, 3HG, 3HH, 3HI, 3HJ, 3HK, 3HL, 3HM, 3HN, 3HO, 3HP, 3HQ, 3HR, 3HS, 3HT, 3HU, 3HV, 3HW, 3HX, 3HY, 3HZ, 3IA, 3IB, 3IC, 3ID, 3IE, 3IF, 3IG, 3IH, 3II, 3IJ, 3IK, 3IL, 3IM, 3IN, 3IO, 3IP, 3IQ, 3IR, 3IS, 3IT, 3IU, 3IV, 3IW, 3IX, 3IY, 3IZ, 3JA, 3JB, 3JC, 3JD, 3JE, 3JF, 3JG, 3JH, 3JI, 3JJ, 3JK, 3JL, 3JM, 3JN, 3JO, 3JP, 3JQ, 3JR, 3JS, 3JT, 3JU, 3JV, 3JW, 3JX, 3JY, 3JZ, 3KA, 3KB, 3KC, 3KD, 3KE, 3KF, 3KG, 3KH, 3KI, 3KJ, 3KK, 3KL, 3KM, 3KN, 3KO, 3KP, 3KQ, 3KR, 3KS, 3KT, 3KU, 3KV, 3KW, 3KX, 3KY, 3KZ, 3LA, 3LB, 3LC, 3LD, 3LE, 3LF, 3LG, 3LH, 3LI, 3LJ, 3LK, 3LM, 3LN, 3LO, 3LP, 3LQ, 3LR, 3LS, 3LT, 3LU, 3LV, 3LW, 3LX, 3LY, 3LZ, 3MA, 3MB, 3MC, 3MD, 3ME, 3MF, 3MG, 3MH, 3MI, 3MJ, 3MK, 3ML, 3MM, 3MN, 3MO, 3MP, 3MQ, 3MR, 3MS, 3MT, 3MU, 3MV, 3MW, 3MX, 3MY, 3MZ, 3NA, 3NB, 3NC, 3ND, 3NE, 3NF, 3NG, 3NH, 3NI, 3NJ, 3NK, 3NL, 3NM, 3NN, 3NO, 3NP, 3NQ, 3NR, 3NS, 3NT, 3NU, 3NV, 3NW, 3NX, 3NY, 3NZ, 3OA, 3OB, 3OC, 3OD, 3OE, 3OF, 3OG, 3OH, 3OI, 3OJ, 3OK, 3OL, 3OM, 3ON, 3OO, 3OP, 3OQ, 3OR, 3OS, 3OT, 3OU, 3OV, 3OW, 3OX, 3OY, 3OZ, 3PA, 3PB, 3PC, 3PD, 3PE, 3PF, 3PG, 3PH, 3PI, 3PJ, 3PK, 3PL, 3PM, 3PN, 3PO, 3PP, 3PQ, 3PR, 3PS, 3PT, 3PU, 3PV, 3PW, 3PX, 3PY, 3PZ, 3QA, 3QB, 3QC, 3QD, 3QE, 3QF, 3QG, 3QH, 3QI, 3QJ, 3QK, 3QL, 3QM, 3QN, 3QO, 3QP, 3QQ, 3QR, 3QS, 3QT, 3QU, 3QV, 3QW, 3QX, 3QY, 3QZ, 3RA, 3RB, 3RC, 3RD, 3RE, 3RF, 3RG, 3RH, 3RI, 3RJ, 3RK, 3RL, 3RM, 3RN, 3RO, 3RP, 3RQ, 3RR, 3RS, 3RT, 3RU, 3RV, 3RW, 3RX, 3RY, 3RZ, 3SA, 3SB, 3SC, 3SD, 3SE, 3SF, 3SG, 3SH, 3SI, 3SJ, 3SK, 3SL, 3SM, 3SN, 3SO, 3SP, 3SQ, 3SR, 3SS, 3ST, 3SU, 3SV, 3SW, 3SX, 3SY, 3SZ, 3TA, 3TB, 3TC, 3TD, 3TE, 3TF, 3TG, 3TH, 3TI, 3TJ, 3TK, 3TL, 3TM, 3TN, 3TO, 3TP, 3TQ, 3TR, 3TS, 3TT, 3TU, 3TV, 3TW, 3TX, 3TY, 3TZ, 3UA, 3UB, 3UC, 3UD, 3UE, 3UF, 3UG, 3UH, 3UI, 3UJ, 3UK, 3UL, 3UM, 3UN, 3UO, 3UP, 3UQ, 3UR, 3US, 3UT, 3UU, 3UV, 3UW, 3UX, 3UY, 3UZ, 3VA, 3VB, 3VC, 3VD, 3VE, 3VF, 3VG, 3VH, 3VI, 3VJ, 3VK, 3VL, 3VM, 3VN, 3VO, 3VP, 3VQ, 3VR, 3VS, 3VT, 3VU, 3VV, 3VW, 3VX, 3VY, 3VZ, 3WA, 3WB, 3WC, 3WD, 3WE, 3WF, 3WG, 3WH, 3WI, 3WJ, 3WK, 3WL, 3WM, 3WN, 3WO, 3WP, 3WQ, 3WR, 3WS, 3WT, 3WU, 3WV, 3WW, 3WX, 3WY, 3WZ, 3XA, 3XB, 3XC, 3XD, 3XE, 3XF, 3XG, 3XH, 3XI, 3XJ, 3XK, 3XL, 3XM, 3XN, 3XO, 3XP, 3XQ, 3XR, 3XS, 3XT, 3XU, 3XV, 3XW, 3XX, 3XY, 3XZ, 3YA, 3YB, 3YC, 3YD, 3YE, 3YF, 3YG, 3YH, 3YI, 3YJ, 3YK, 3YL, 3YM, 3YN, 3YO, 3YP, 3YQ, 3YR, 3YS, 3YT, 3YU, 3YV, 3YW, 3YX, 3YY, 3YZ, 3ZA, 3ZB, 3ZC, 3ZD, 3ZE, 3ZF, 3ZG, 3ZH, 3ZI, 3ZJ, 3ZK, 3ZL, 3ZM, 3ZN, 3ZO, 3ZP, 3ZQ, 3ZR, 3ZS, 3ZT, 3ZU, 3ZV, 3ZW, 3ZX, 3ZY, 3ZZ, 4AA, 4AB, 4AC, 4AD, 4AE, 4AF, 4AG, 4AH, 4AI, 4AJ, 4AK, 4AL, 4AM, 4AN, 4AO, 4AP, 4AQ, 4AR, 4AS, 4AT, 4AU, 4AV, 4AW, 4AX, 4AY, 4AZ, 4BA, 4BB, 4BC, 4BD, 4BE, 4BF, 4BG, 4BH, 4BI, 4BJ, 4BK, 4BL, 4BM, 4BN, 4BO, 4BP, 4BQ, 4BR, 4BS, 4BT, 4BU, 4BV, 4BW, 4BX, 4BY, 4BZ, 4CA, 4CB, 4CC, 4CD, 4CE, 4CF, 4CG, 4CH, 4CI, 4CJ, 4CK, 4CL, 4CM, 4CN, 4CO, 4CP, 4CQ, 4CR, 4CS, 4CT, 4CU, 4CV, 4CW, 4CX, 4CY, 4CZ, 4DA, 4DB, 4DC, 4DD, 4DE, 4DF, 4DG, 4DH, 4DI, 4DJ, 4DK, 4DL, 4DM, 4DN, 4DO, 4DP, 4DQ, 4DR, 4DS, 4DT, 4DU, 4DV, 4DW, 4DX, 4DY, 4DZ, 4EA, 4EB, 4EC, 4ED, 4EE, 4EF, 4EG, 4EH, 4EI, 4EJ, 4EK, 4EL, 4EM, 4EN, 4EO, 4EP, 4EQ, 4ER, 4ES, 4ET, 4EU, 4EV, 4EW, 4EX, 4EY, 4EZ, 4FA, 4FB, 4FC, 4FD, 4FE, 4FF, 4FG, 4FH, 4FI, 4FJ, 4FK, 4FL, 4FM, 4FN, 4FO, 4FP, 4FQ, 4FR, 4FS, 4FT, 4FU, 4FV, 4FW, 4FX, 4FY, 4FZ, 4GA, 4GB, 4GC, 4GD, 4GE, 4GF, 4GG, 4GH, 4GI, 4GJ, 4GK, 4GL, 4GM, 4GN, 4GO, 4GP, 4GQ, 4GR, 4GS, 4GT, 4GU, 4GV, 4GW, 4GX, 4GY, 4GZ, 4HA, 4HB, 4HC, 4HD, 4HE, 4HF, 4HG, 4HH, 4HI, 4HJ, 4HK, 4HL, 4HM, 4HN, 4HO, 4HP, 4HQ, 4HR, 4HS, 4HT, 4HU, 4HV, 4HW, 4HX, 4HY, 4HZ, 4IA, 4IB, 4IC, 4ID, 4IE, 4IF, 4IG, 4IH, 4II, 4IJ, 4IK, 4IL, 4IM, 4IN, 4IO, 4IP, 4IQ, 4IR, 4IS, 4IT, 4IU, 4IV, 4IW, 4IX, 4IY, 4IZ, 4JA, 4JB, 4JC, 4JD, 4JE, 4JF, 4JG, 4JH, 4JI, 4JJ, 4JK, 4JL, 4JM, 4JN, 4JO, 4JP, 4JQ, 4JR, 4JS, 4JT, 4JU, 4JV, 4JW, 4JX, 4JY, 4JZ, 4KA, 4KB, 4KC, 4KD, 4KE, 4KF, 4KG, 4KH, 4KI, 4KJ, 4KK, 4KL, 4KM, 4KN, 4KO, 4KP, 4KQ, 4KR, 4KS, 4KT, 4KU, 4KV, 4KW, 4KX, 4KY, 4KZ, 4LA, 4LB, 4LC, 4LD, 4LE, 4LF, 4LG, 4LH, 4LI, 4LJ, 4LK, 4LM, 4LN, 4LO, 4LP, 4LQ, 4LR, 4LS, 4LT, 4LU, 4LV, 4LW, 4LX, 4LY, 4LZ, 4MA, 4MB, 4MC, 4MD, 4ME, 4MF, 4MG, 4MH, 4MI, 4MJ, 4MK, 4ML, 4MM, 4MN, 4MO, 4MP, 4MQ, 4MR, 4MS, 4MT, 4MU, 4MV, 4MW, 4MX, 4MY, 4MZ, 4NA, 4NB, 4NC, 4ND, 4NE, 4NF, 4NG, 4NH, 4NI, 4NJ, 4NK, 4NL, 4NM, 4NN, 4NO, 4NP, 4NQ, 4NR, 4NS, 4NT, 4NU, 4NV, 4NW, 4NX, 4NY, 4NZ, 4OA, 4OB, 4OC, 4OD, 4OE, 4OF, 4OG, 4OH, 4OI, 4OJ, 4OK, 4OL, 4OM, 4ON, 4OO, 4OP, 4OQ, 4OR, 4OS, 4OT, 4OU, 4OV, 4OW, 4OX, 4OY, 4OZ, 4PA, 4PB, 4PC, 4PD, 4PE, 4PF, 4PG, 4PH, 4PI, 4PJ, 4PK, 4PL, 4PM, 4PN, 4PO, 4PP, 4PQ, 4PR, 4PS, 4PT, 4PU, 4PV, 4PW, 4PX, 4PY, 4PZ, 4QA, 4QB, 4QC, 4QD, 4QE, 4QF, 4QG, 4QH, 4QI, 4QJ, 4QK, 4QL, 4QM, 4QN, 4QO, 4QP, 4QQ, 4QR, 4QS, 4QT, 4QU, 4QV, 4QW, 4QX, 4QY, 4QZ, 4RA, 4RB, 4RC, 4RD, 4RE, 4RF, 4RG, 4RH, 4RI, 4RJ, 4RK, 4RL, 4RM, 4RN, 4RO, 4RP, 4RQ, 4RR, 4RS, 4RT, 4RU, 4RV, 4RW, 4RX, 4RY, 4RZ, 4SA, 4SB, 4SC, 4SD, 4SE, 4SF, 4SG, 4SH, 4SI, 4SJ, 4SK, 4SL, 4SM, 4SN, 4SO, 4SP, 4SQ, 4SR, 4SS, 4ST, 4SU, 4SV, 4SW, 4SX, 4SY, 4SZ, 4TA, 4TB, 4TC, 4TD, 4TE, 4TF, 4TG, 4TH, 4TI, 4TJ, 4TK, 4TL, 4TM, 4TN, 4TO, 4TP, 4TQ, 4TR, 4TS, 4TT, 4TU, 4TV, 4TW, 4TX, 4TY, 4TZ, 4UA, 4UB, 4UC, 4UD, 4UE, 4UF, 4UG, 4UH, 4UI, 4UJ, 4UK, 4UL, 4UM, 4UN, 4UO, 4UP, 4UQ, 4UR, 4US, 4UT, 4UU, 4UV, 4UW, 4UX, 4UY, 4UZ, 4VA, 4VB, 4VC, 4VD, 4VE, 4VF, 4VG, 4VH, 4VI, 4VJ, 4VK, 4VL, 4VM, 4VN, 4VO, 4VP, 4VQ, 4VR, 4VS, 4VT, 4VU, 4VV, 4VW, 4VX, 4VY, 4VZ, 4WA, 4WB, 4WC, 4WD, 4WE, 4WF, 4WG, 4WH, 4WI, 4WJ, 4WK, 4WL, 4WM, 4WN, 4WO, 4WP, 4WQ, 4WR, 4WS, 4WT, 4WU, 4W

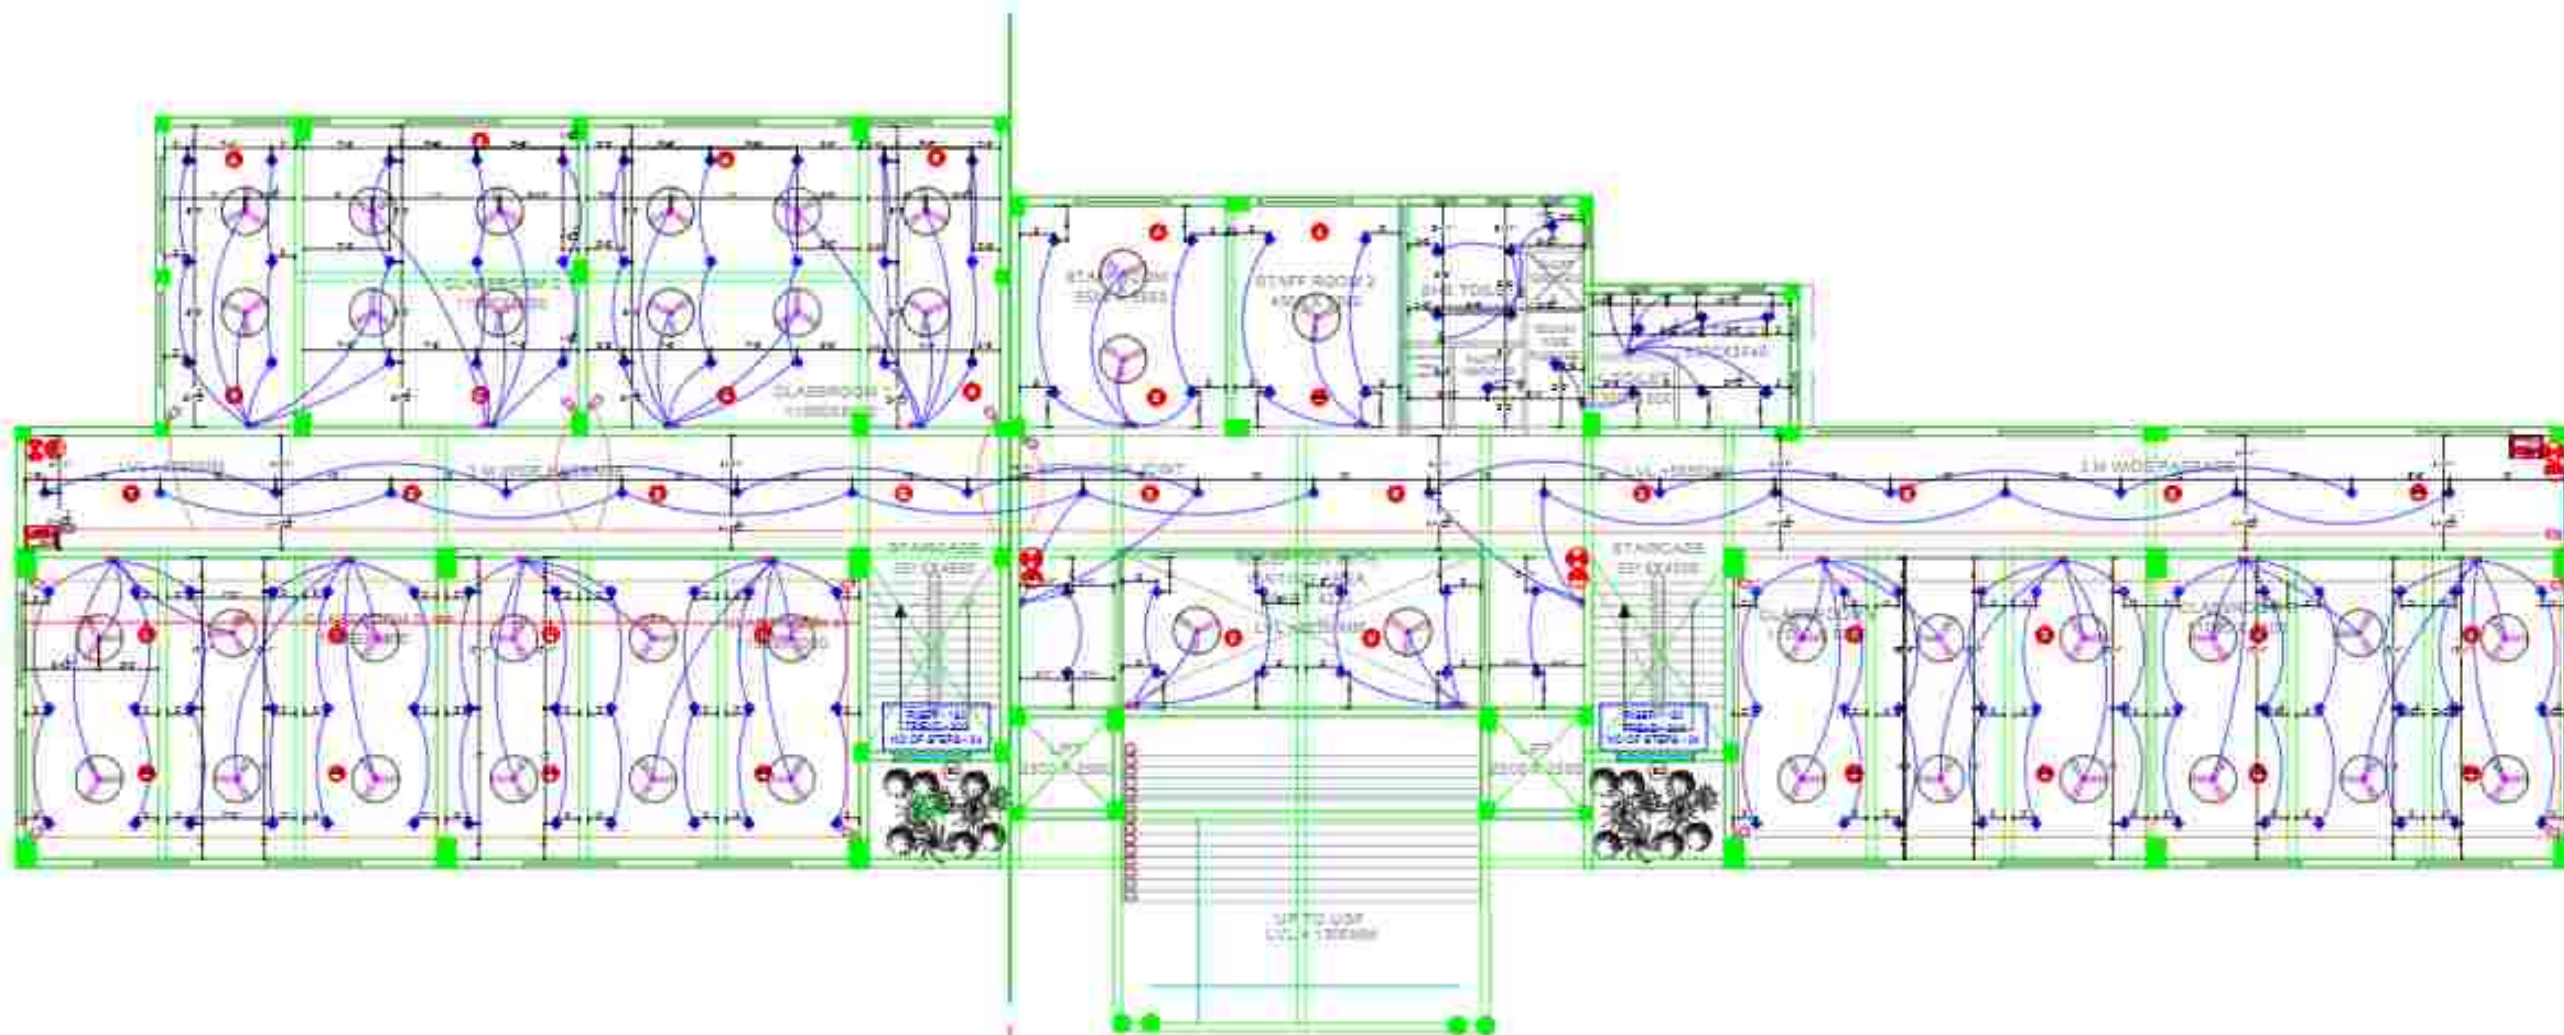

FIRST FLOOR

LEGEND		
1	Switch	20Amps
2	Switch	10Amps
3	Switch	5Amps
4	Switch	2.5Amps
5	Switch	1.5Amps
6	Switch	0.75Amps
7	Switch	0.375Amps
8	Switch	0.1875Amps
9	Switch	0.09375Amps
10	Switch	0.046875Amps
11	Switch	0.0234375Amps
12	Switch	0.01171875Amps
13	Switch	0.005859375Amps
14	Switch	0.0029296875Amps

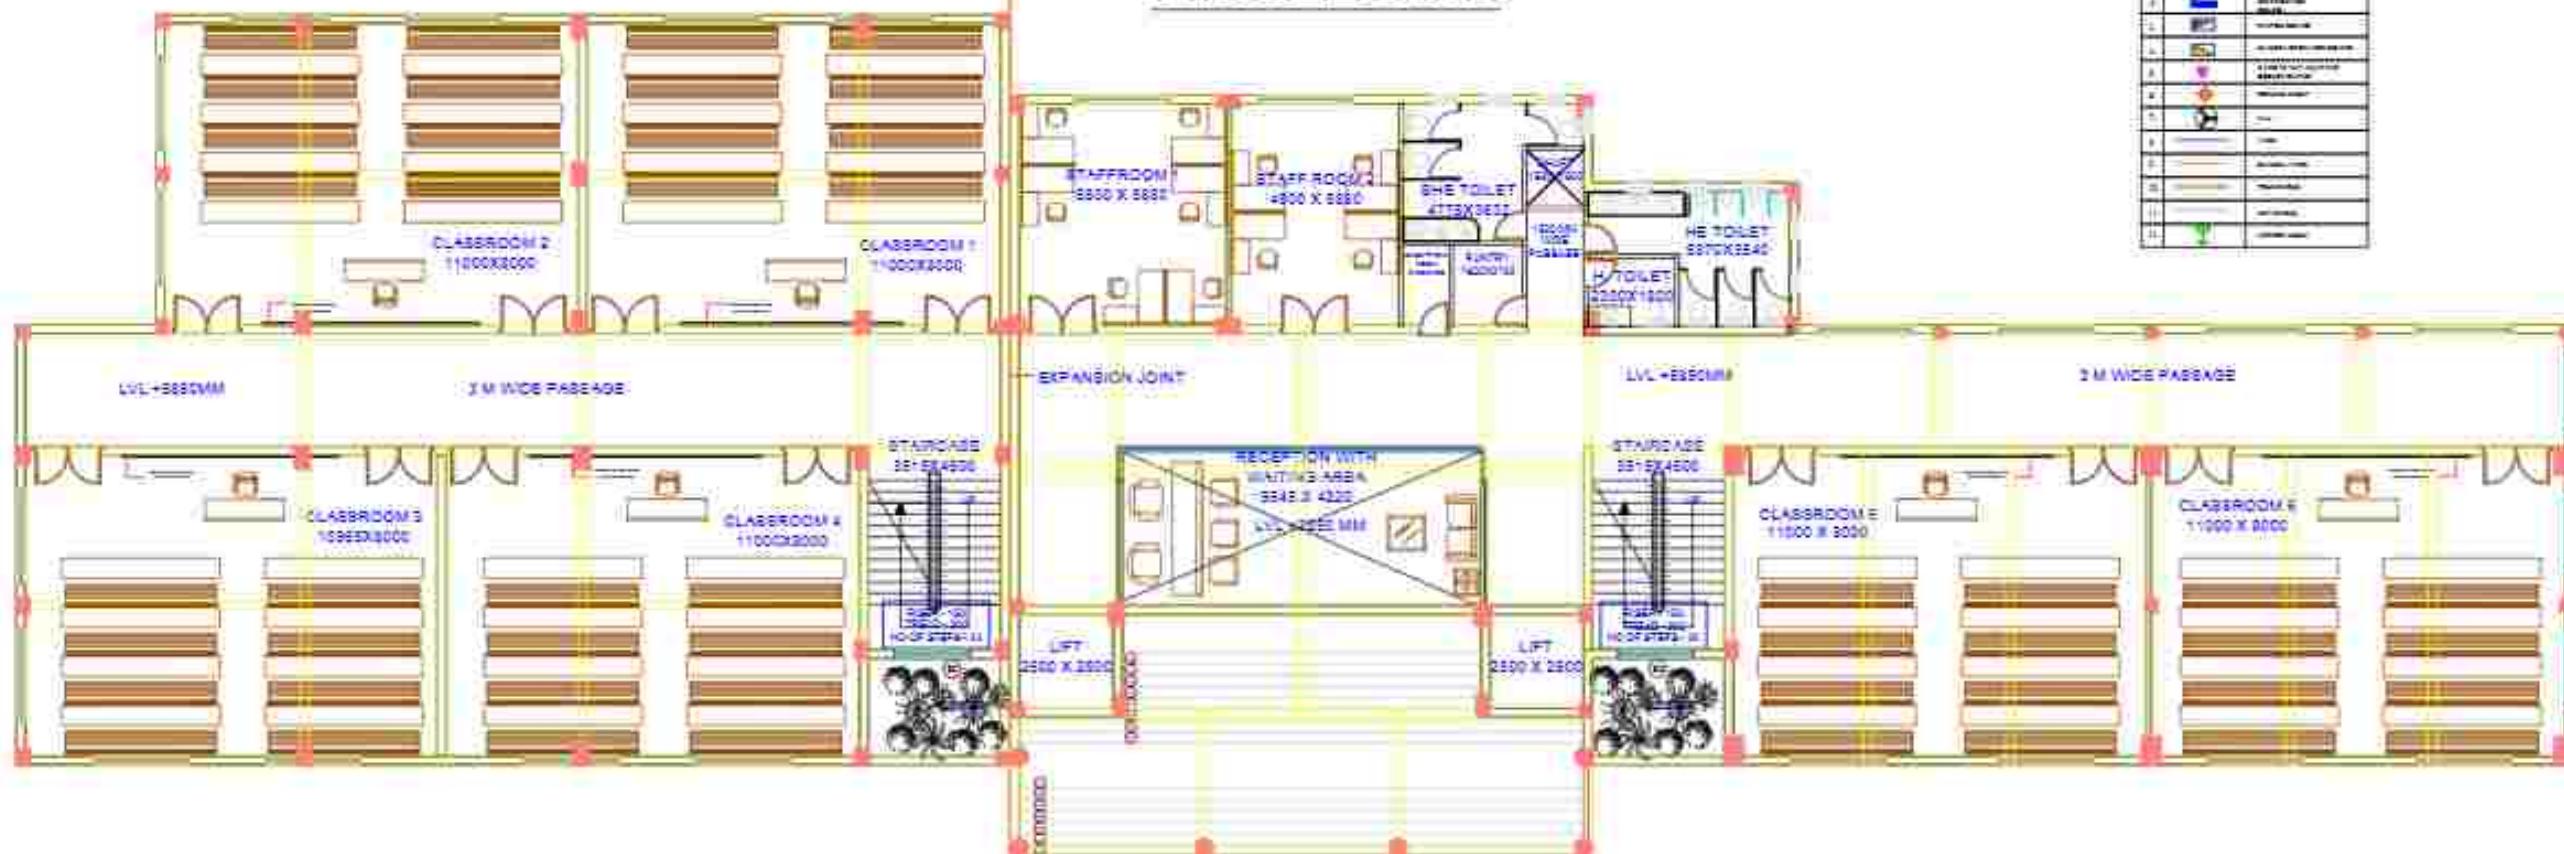

FIRST FLOOR

NOTE

1. Work during the progress of 2023-24 study and is not to be reproduced or used in any form without the permission of the owner.
2. All dimensions are in meters unless otherwise specified.
3. Drawings are subject to change without notice.
4. All dimensions are to be taken to the center of the structure and not to the outer edge of the walls.

OWNER / CLIENT

RAJ BHAWAN

ARCHITECTURAL CONSULTANT

AR. GAURAV GUPTA

DRAWING TITLE:

LAW COLLEGE-
ELECTRICAL
(UPPER GROUND FLOOR)

NORTH

DRAWN BY: AR. MOHD. HAS

SCALE: N.T.S

CHKD BY: AR. GAURAV GUPTA

DATE: 07-03-2023

OFFICE STAMP:



DE: CA+PE STUDIO


COLLECTION & ARCHITECTURE & PLANNING

1A - 20, MOHD. HAS, MOHD. HAS, MOHD. HAS

1A - 20, MOHD. HAS, MOHD. HAS, MOHD. HAS


1A - 20, MOHD. HAS, MOHD. HAS, MOHD. HAS

1A - 20, MOHD. HAS, MOHD. HAS, MOHD. HAS

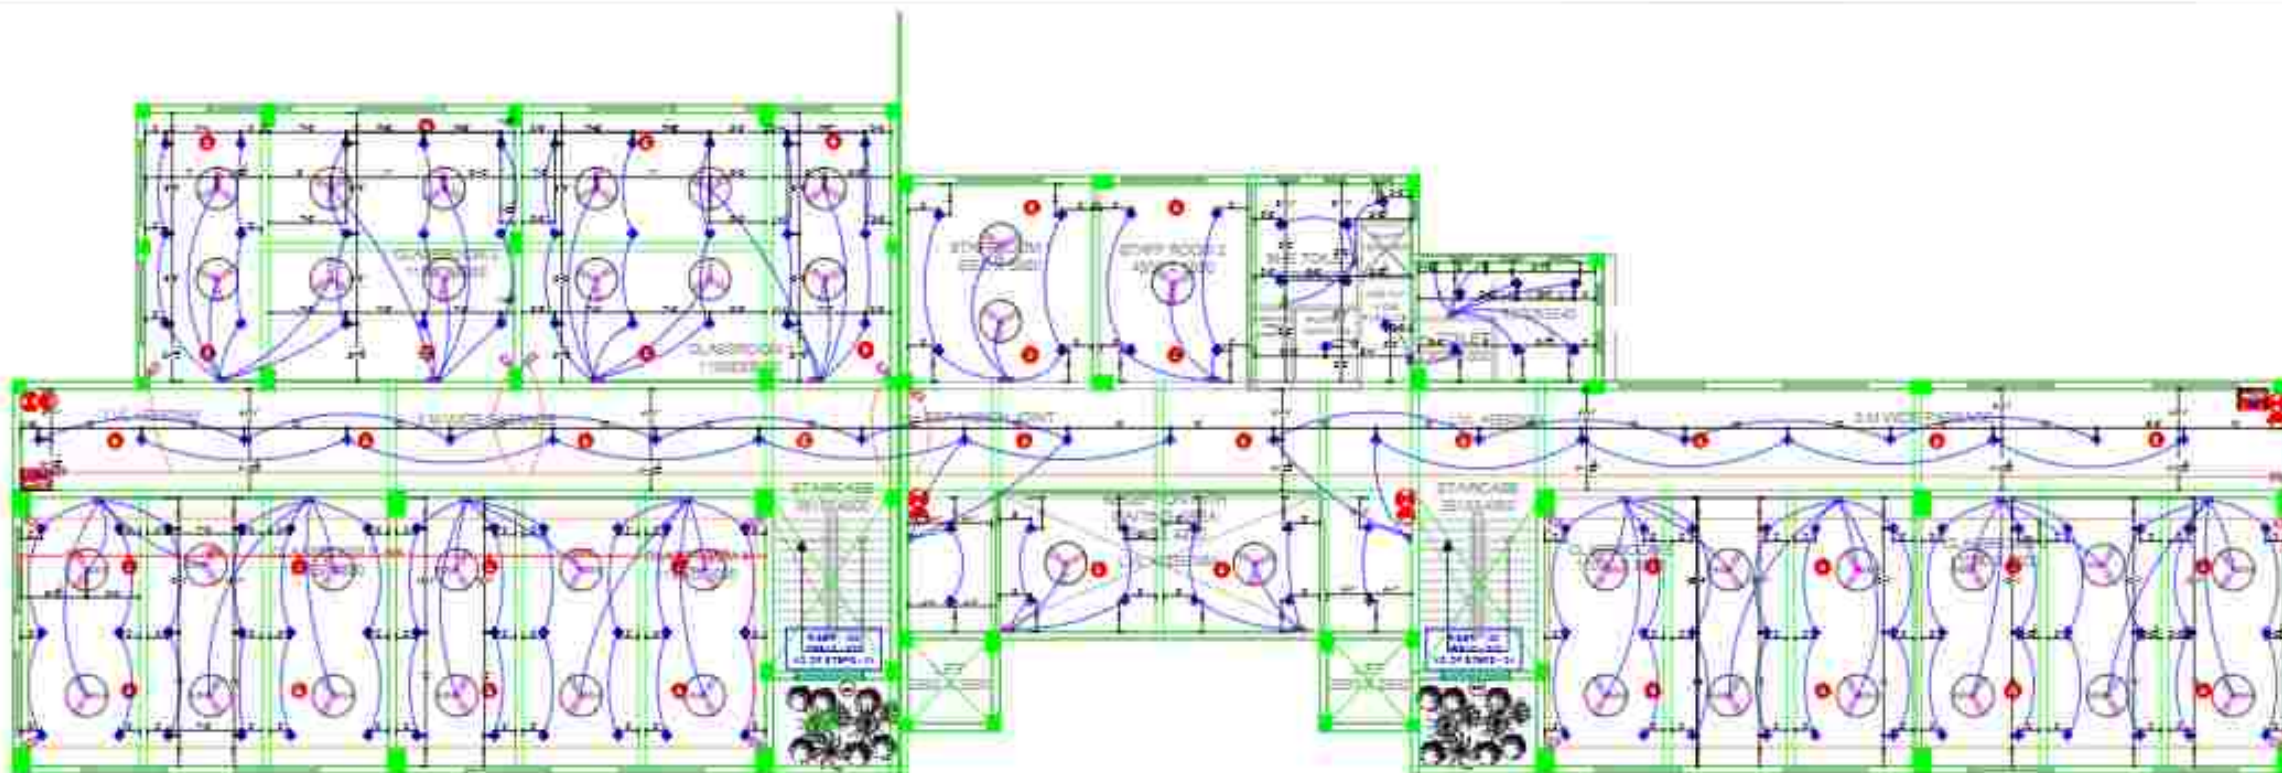

SECOND FLOOR

NO.	SYMBOL	DESCRIPTION
1	[Symbol]	Switch
2	[Symbol]	Light
3	[Symbol]	Socket
4	[Symbol]	Door
5	[Symbol]	Window
6	[Symbol]	Staircase
7	[Symbol]	Room
8	[Symbol]	Corridor
9	[Symbol]	Room
10	[Symbol]	Room
11	[Symbol]	Room
12	[Symbol]	Room

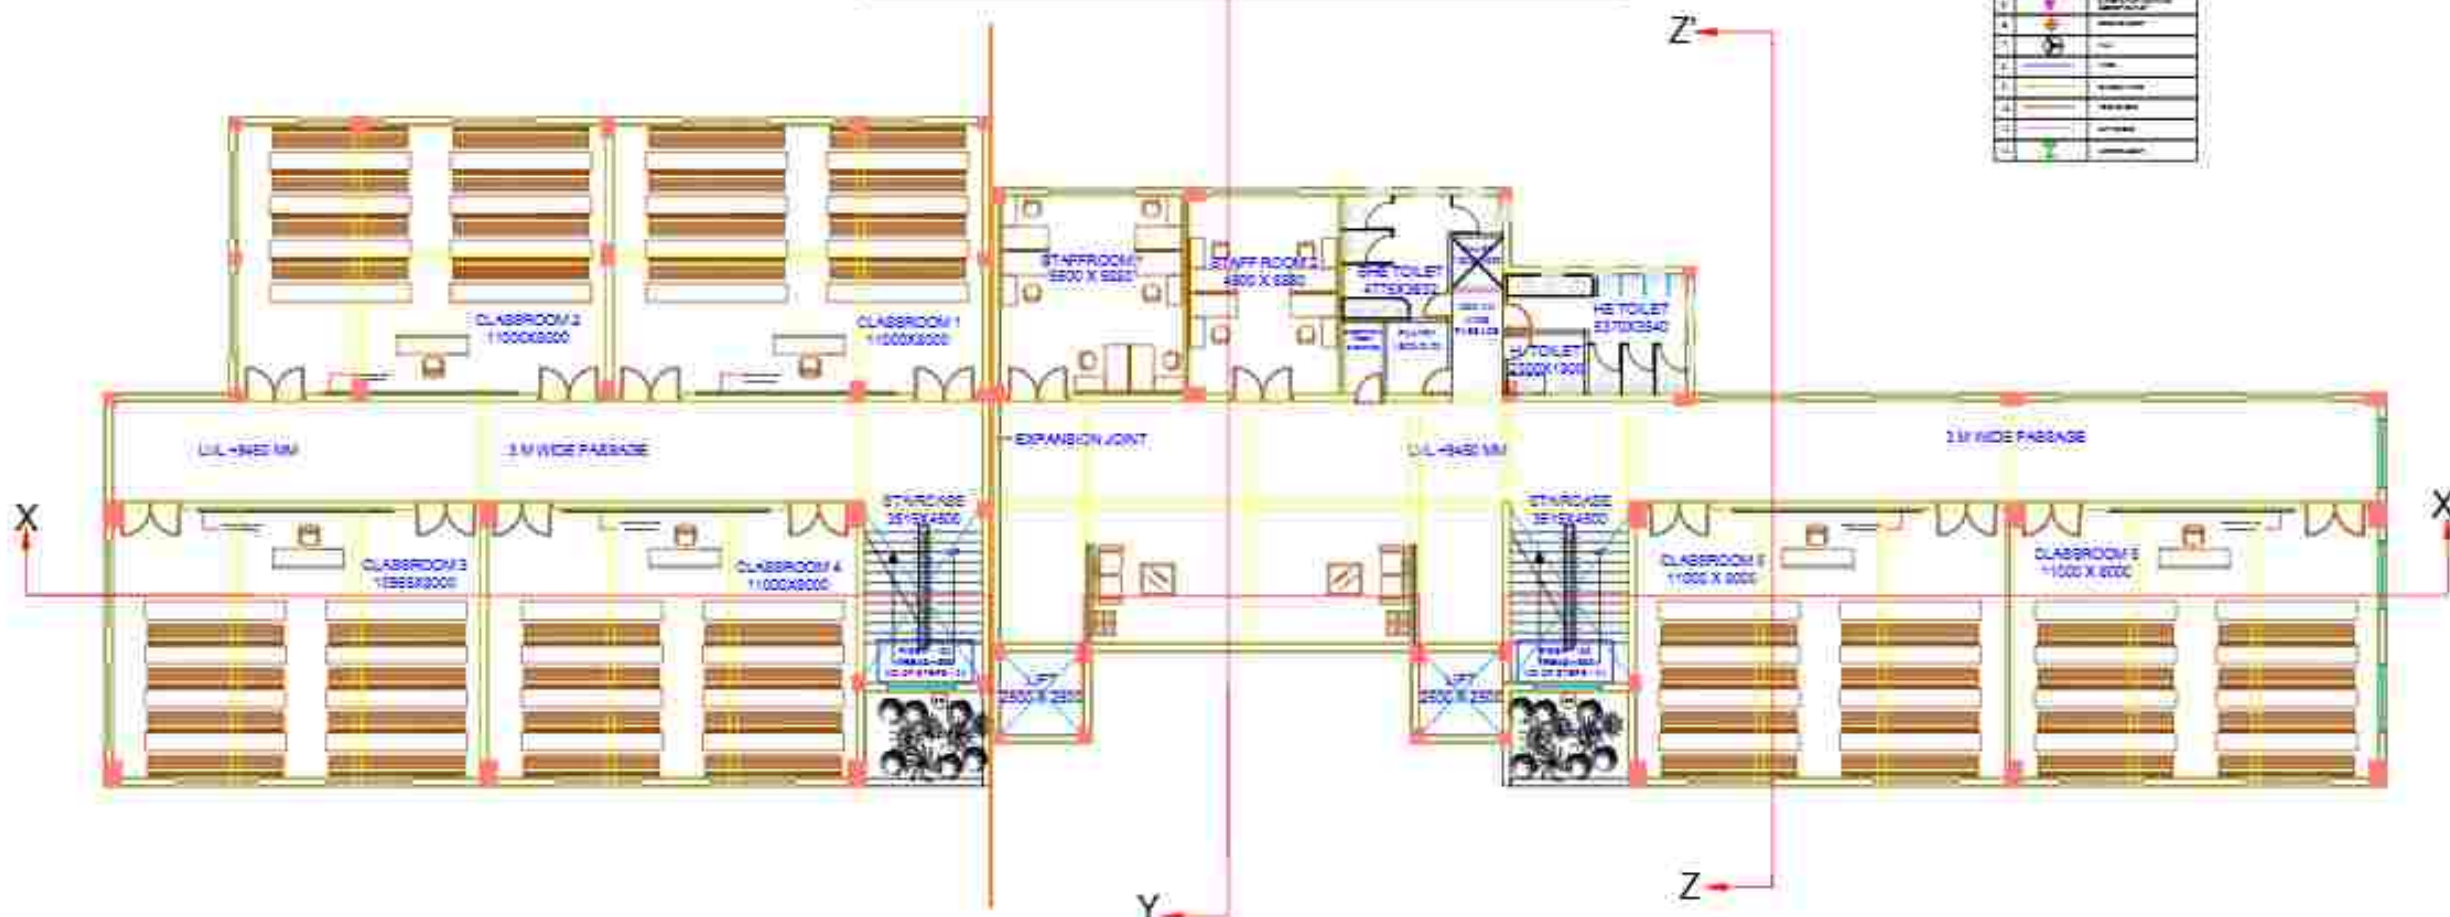

SECOND FLOOR

NOTE

1. Work during the progress of the project should be as per the approved layout and plan.
2. All dimensions are in meters unless otherwise specified.
3. Drawings are subject to change without notice.
4. All dimensions are to be taken to the center of the structure and not to the outer edge of the walls.

OWNER / CLIENT

RAJ BHAWAN

ARCHITECTURAL CONSULTANT

AR. GAURAV GUPTA

DRAWING TITLE:

LAW COLLEGE-
ELECTRICAL
(SECOND GROUND FLOOR)

NORTH

DRAWN BY: AR. MOHD. HASAN

SCALE: N.T.S.

CHKD BY: AR. GAURAV GUPTA

DATE: 07-03-2023

OFFICE STAMP



DE: CA+PE STUDIO


COLLECTION OF ARCHITECTURE & PLANNING DRAWINGS

1A - 1B, 1C, 1D, 1E, 1F, 1G, 1H, 1I, 1J, 1K, 1L, 1M, 1N, 1O, 1P, 1Q, 1R, 1S, 1T, 1U, 1V, 1W, 1X, 1Y, 1Z

1A - 1B, 1C, 1D, 1E, 1F, 1G, 1H, 1I, 1J, 1K, 1L, 1M, 1N, 1O, 1P, 1Q, 1R, 1S, 1T, 1U, 1V, 1W, 1X, 1Y, 1Z

1A - 1B, 1C, 1D, 1E, 1F, 1G, 1H, 1I, 1J, 1K, 1L, 1M, 1N, 1O, 1P, 1Q, 1R, 1S, 1T, 1U, 1V, 1W, 1X, 1Y, 1Z

1A - 1B, 1C, 1D, 1E, 1F, 1G, 1H, 1I, 1J, 1K, 1L, 1M, 1N, 1O, 1P, 1Q, 1R, 1S, 1T, 1U, 1V, 1W, 1X, 1Y, 1Z

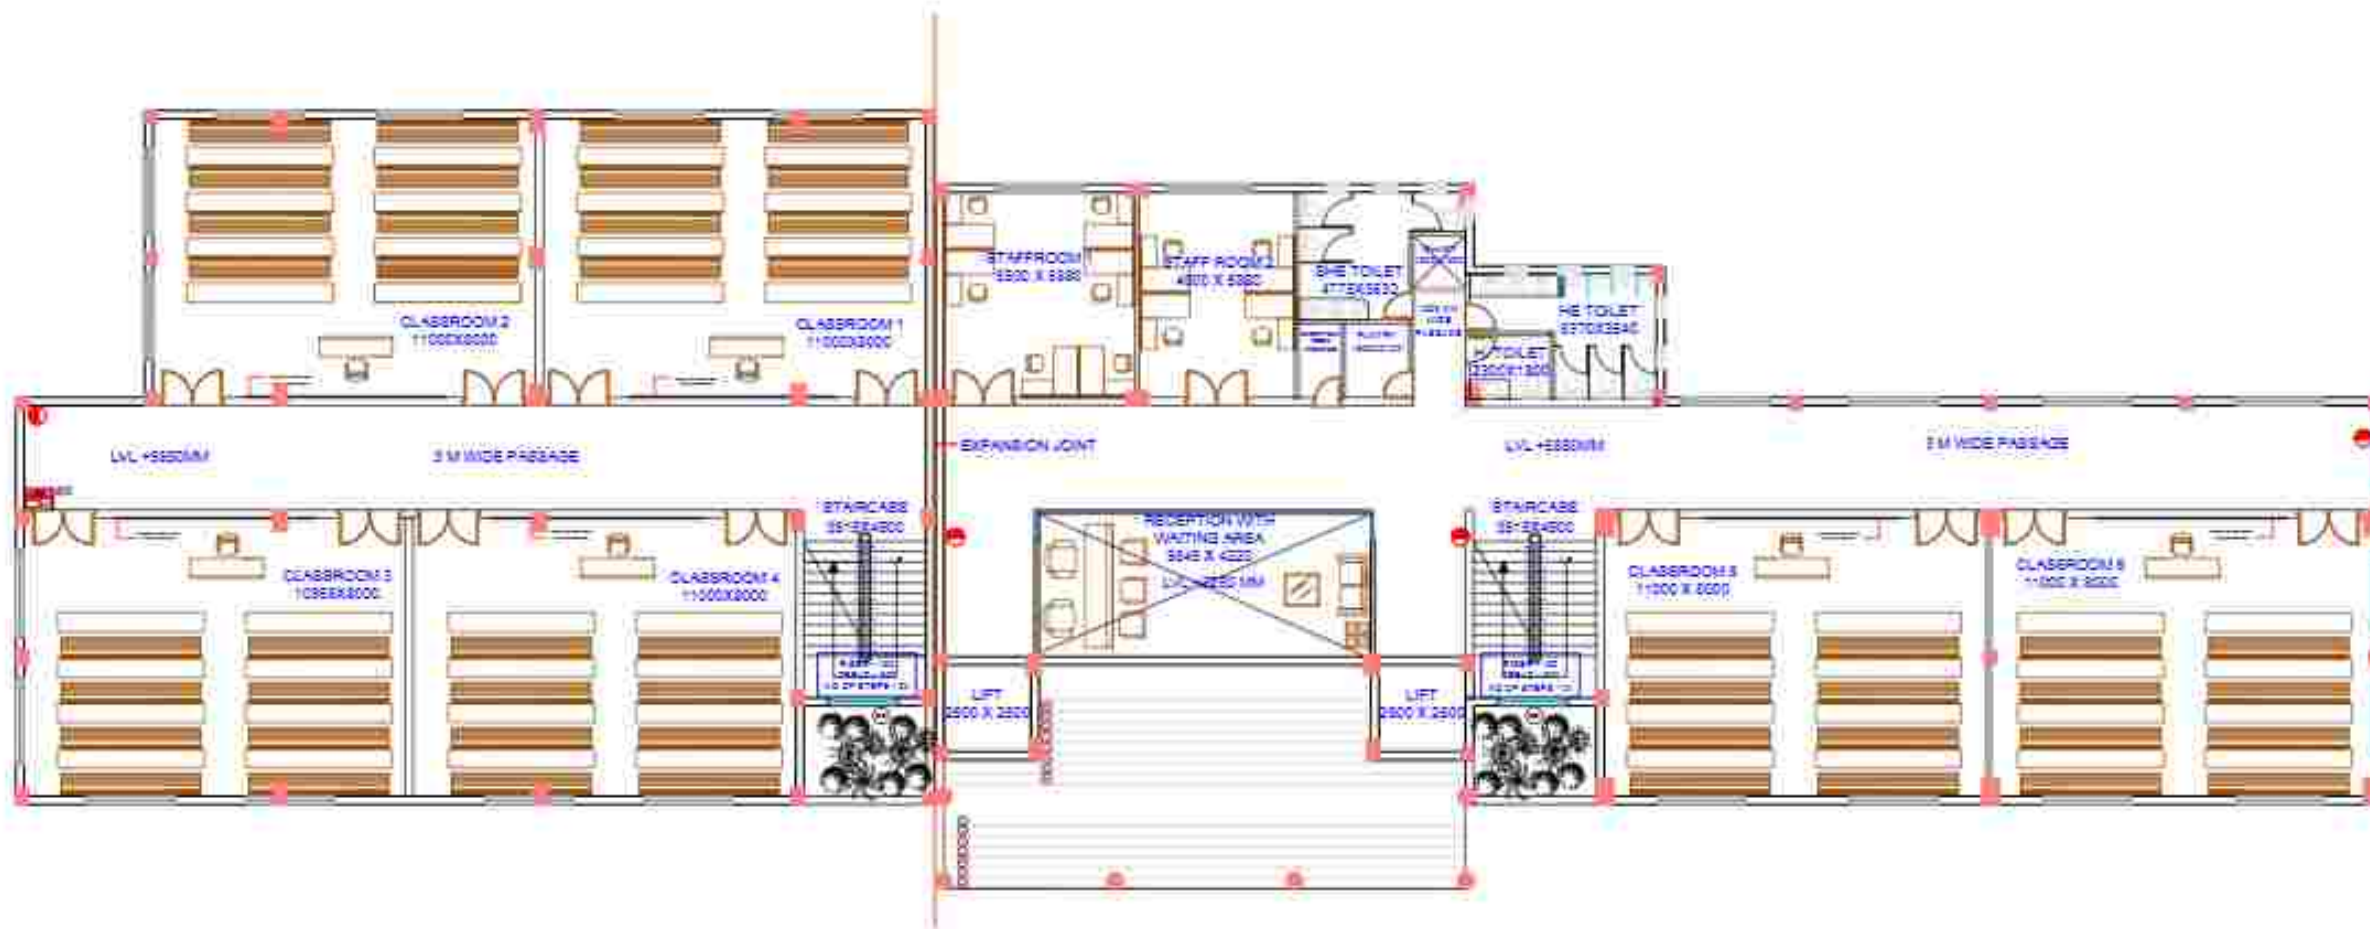

LOWER GROUND FLOOR

NOTE:

1. This drawing is a property of De Ca+Pe Studio and is not to be reproduced copied or handed over in any form except for the purpose for which it is intended.
2. All dimension are in Feet/inches except where mentioned.
3. Drawings are not to be scaled written dimensions are to be followed.
4. All discrepancies to be brought to the notice of the Architect and resolved before commencement of any work.

Architectural Consultant: Ar. Gaurav Gupta

Electrical Consultant: Plumbing Consultant

Client/Owner: BHARAT SEWA SANSTHAN

Project Description: CHANDRABHAN GUPT LAW COLLEGE




Drawing Title: LAW COLLEGE- FIRE FIGHTING (LOWER GROUND FLOOR)

Date: 26/08/2025
Drawn By: AMITA YADAV
Checked By: AR. GAURAV GUPTA
Scale: 1/4" = 1'-0"

Project Code:
Sheet No.:


Office Stamp

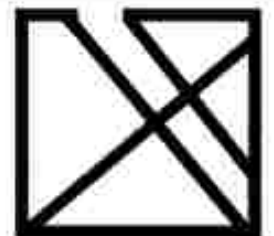

DE: CA+PE STUDIO

Collaborative Architecture & Planning Environment

Head Office - L2-155, Sector G, LDA colony, Astiyana
Kanpur Road near Roy Hospital, behind Spring Dale
School, Lucknow - 226012
Branch Office - 8/1, Basement, Kalkaji extension,
Delhi - 110019
Contact no - +91 99350 05439
E-Mail- studio.decape18@gmail.com
info.decapestudio@gmail.com

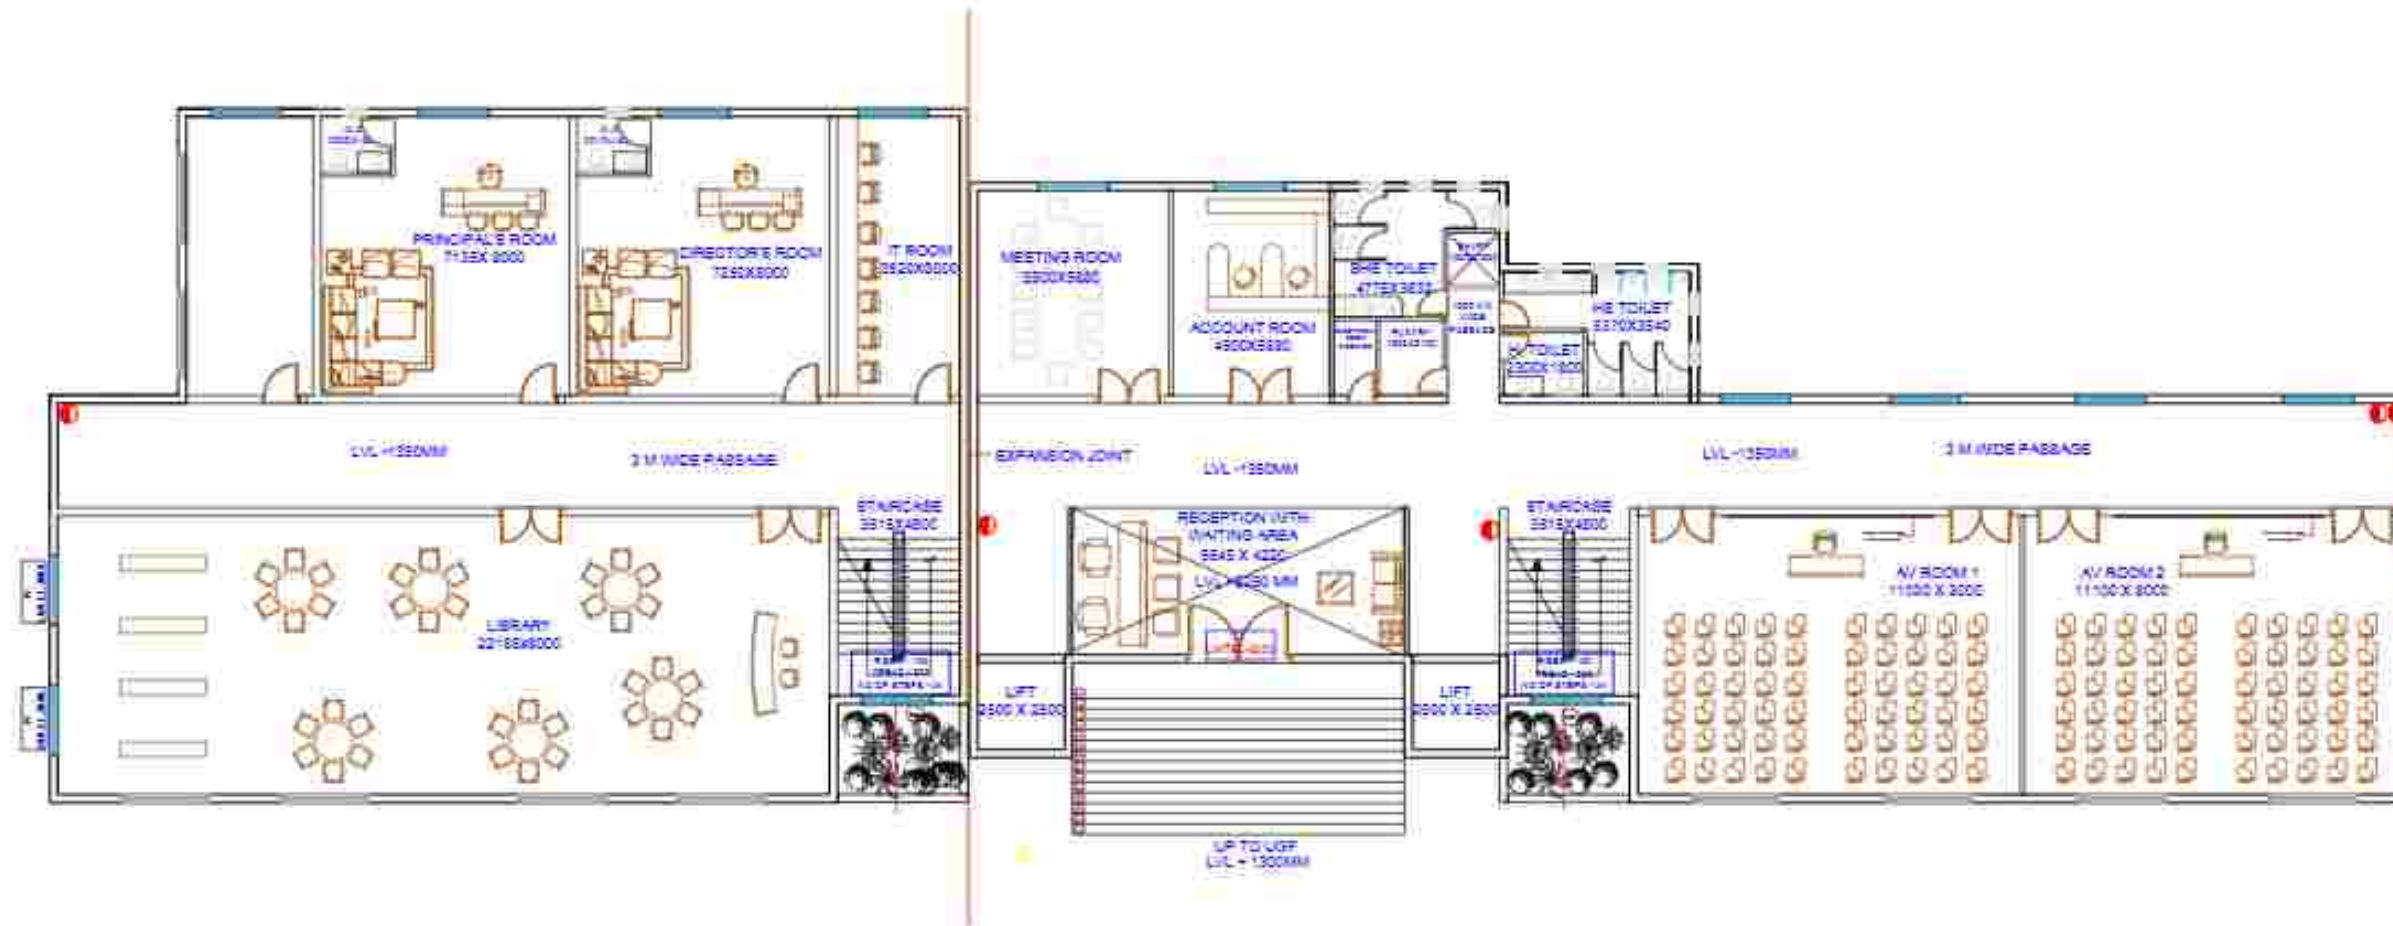

UPPER GROUND FLOOR

NOTE:

1. This drawing is a property of De Ca+Pe Studio and is not to be reproduced copied or handed over in any form except for the purpose for which it is intended.
2. All dimension are in Feet/inches except where mentioned.
3. Drawings are not to be scaled written dimensions are to be followed.
4. All discrepancies to be brought to the notice of the Architect and resolved before commencement of any work.

Architectural Consultant: Ar. Gaurav Gupta

 
Structural Consultant

Electrical Consultant

Plumbing Consultant

Client/Owner: BHARAT SEWA SANSTHAN

Project Description: CHANDRABHAN GUPT LAW COLLEGE




Drawing Title: LAW COLLEGE- FIRE FIGHTING (UPPER GROUND FLOOR)

Date: 26/08/2025
Drawn By: AMITA YADAV
Checked By: AR. GAURAV GUPTA
Scale: 1/4" = 1'-0"

Project Code: -
Sheet No: -

Office Stamp

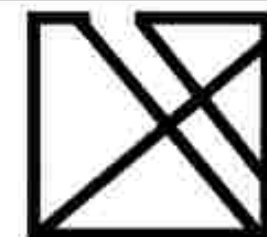

DE: CA+PE STUDIO

Collaborative Architecture & Planning Environment

Head Office - L2-155, Sector G, LDA colony, Astiyana
Kanpur Road near Roy Hospital, behind Spring Dale
School, Lucknow - 226012
Branch Office - 8/1, Basement, Kalkaji extension,
Delhi - 110019
Contact no - +91 99350 05439
E-Mail- studio.decape18@gmail.com
info.decapestudio@gmail.com



FIRST FLOOR

NOTE:

1. This drawing is a property of De Ca+Pe Studio and is not to be reproduced copied or handed over in any form except for the purpose for which it is intended.
2. All dimension are in Feet/inches except where mentioned.
3. Drawings are not to be scaled written dimensions are to be followed.
4. All discrepancies to be brought to the notice of the Architect and resolved before commencement of any work.

Architectural Consultant: Ar. Gaurav Gupta

Electrical Consultant: Plumbing Consultant

Client/Owner: BHARAT SEWA SANSTHAN

Project Description: CHANDRABHAN GUPT LAW COLLEGE




Drawing Title: LAW COLLEGE- FIRE FIGHTING (FIRST GROUND FLOOR)

Date:- 26/08/2025
Drawn By:- AMITA YADAV
Checked By:- AR. GAURAV GUPTA
Scale:- 1/4" = 1'-0"

Project Code:-
Sheet No:-

Office Stamp

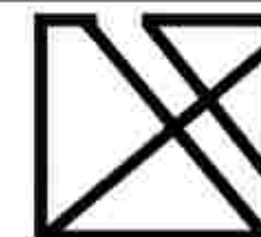


DE: CA+PE STUDIO


Collaborative Architecture & Planning Environment

Head Office - L2-155, Sector G, LDA colony, Ashiyana Kanpur Road near Roy Hospital, behind Spring Dale School, Lucknow - 226012
Branch Office - 8/1, Basement, Kalkaji extension, Delhi- 110019
Contact no - +91 99350 05439
E-Mail- studio.decape18@gmail.com
info.decapestudio@gmail.com

1. This drawing is a property of De Ca+Pe Studio and is not to be reproduced copied or handed over in any form except for the purpose for which it is intended.
2. All dimension are in Feet/inches except where mentioned.
3. Drawings are not to be scaled written dimensions are to be followed.
4. All discrepancies to be brought to the notice of the Architect and resolved before commencement of any work.

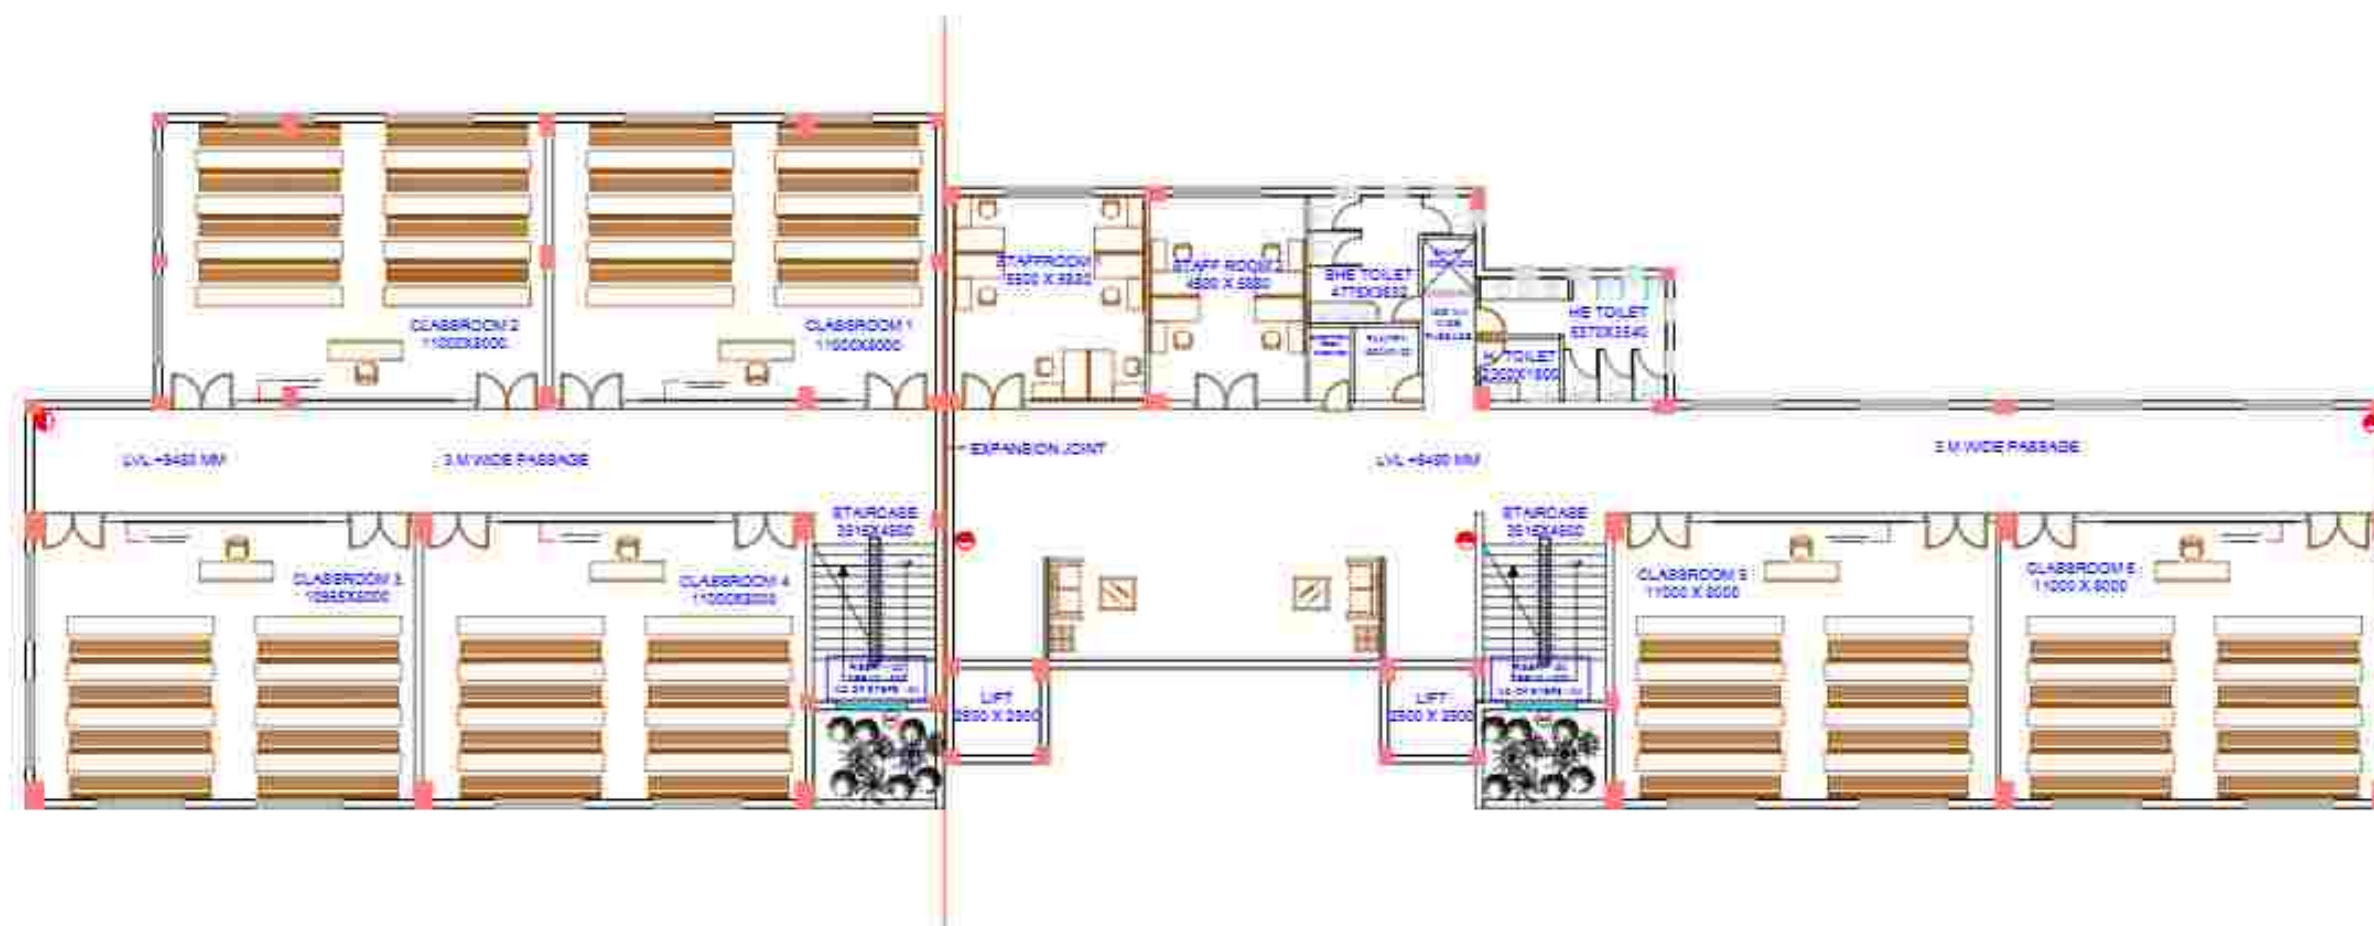

SECOND FLOOR

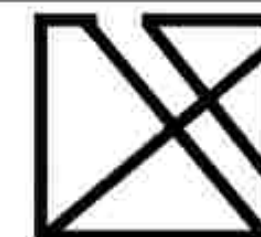

DE: CA+PE STUDIO

Collaborative Architecture & Planning Environment

Head Office - L2-155, Sector G, LDA colony, Asthivana

Kanpur Road near Roy Hospital, behind Spring Dale

School, Lucknow - 226012
Branch Office - 211, Bazaar, Kalkaji extension

Branch Office - 8/1, Basement, Kalkaji extension,
Delhi-110019

Contact no. +91 99350 05439

E-Mail- studio.decape18@gmail.com
<http://www.studio18.com>

info: decapestudio@gmail.com

Chandrabhan Gupta Law College

S. NO.	Floor Name	Location	Type	Capacity	Qty
1	Lower Ground Floor	Gallery In front of Class Room 1-4	ABC	6 Kgs	4
		Side Gallery	ABC	6 Kgs	2
		Staff Room (2 Nos.) Inside	ABC	2 Kgs	2
		Waiting / Reception Area	ABC	6 Kgs	1
		Electrical Room Inside	Co2	4.5 Kgs.	1
		Electrical Room Inside	ABC	6 Kgs	1
		Electrical Room Inside (AUTO / Mannual)	ABC & E	580 ML	1
		Pantry (In Side)	ABC	2 Kgs	1
		Gallery In front of Class Room 5-6	ABC	6 Kgs	2
2	Upper Ground Floor	Outside Principal's & Director's Room	ABC	6 Kgs	1
		Library (Inside)	ABC	6 Kgs	1
		I T Room	Clean Agent	2 Kgs	2
		I.T. Room Inside (AUTO / Mannual)	ABC & E	580 ML	1
		Server Rack Suppression System	Clean Agent	2 Kgs	1
		Outside Meeting & Accounts Room	ABC	6 Kgs	1
		Reception & Waiting Area	ABC	6 Kgs	1
		Electrical Room Inside	Co2	4.5 Kgs.	1
		Electrical Room Inside	ABC	6 Kgs	1
		Electrical Room Inside (AUTO / Mannual)	ABC & E	580 ML	1
		Pantry (In Side)	ABC	2 Kgs	1
		Audio Video room Corridore	ABC	6 Kgs	2
		Audio Video Room : 1 (Inside)	ABC	6 Kgs	4
		Audio Video Room : 2 (Inside)	ABC	6 Kgs	4

3	First Floor	Gallery In front of Class Room 1-4	ABC	6 Kgs.	4
		Side Gallery	ABC	6 Kgs.	2
		Staff Room (2 Nos.) Inside	ABC	2 Kgs.	2
		Waiting / Reception Area	ABC	6 Kgs.	1
		Electrical Room Inside	Co2	4.5 Kgs.	1
		Electrical Room Inside	ABC	6 Kgs.	1
		Electrical Room Inside (AUTO / Mannual)	ABC & E	580 ML	1
		Pantry (In Side)	ABC	2 Kgs.	1
		Gallery In front of Class Room 5-6	ABC	6 Kgs.	2
4	Second Floor	Gallery In front of Class Room 1-4	ABC	6 Kgs.	4
		Side Gallery	ABC	6 Kgs.	2
		Staff Room (2 Nos.) Inside	ABC	2 Kgs.	2
		Waiting / Reception Area	ABC	6 Kgs.	1
		Electrical Room Inside	Co2	4.5 Kgs.	1
		Electrical Room Inside	ABC	6 Kgs.	1
		Electrical Room Inside (AUTO / Mannual)	ABC & E	580 ML	1
		Pantry (In Side)	ABC	2 Kgs.	1
		Gallery In front of Class Room 5-6	ABC	6 Kgs.	2
5	Electrical & Genset Area	Inside Electrical Room	Co2	4.5 Kgs.	2
		Inside Electrical Room	ABC	6 Kgs.	1
		Electrical Room Inside (AUTO / Mannual)	ABC & E	580 ML	1
		D. G. Set Room & Area	Foam Type	9 Ltrs	2
		D.G. Set Room & Area	Foam Type	45 Ltrs	1
TOTAL QUANTITY					74

Type	Capacity	Quantity	Remark
ABC	2 Kgs	10	
ABC	6 Kgs.	46	
Co2	4.5 Kgs.	6	
Foam Type	9 Ltrs	2	
Foam Type	45 Ltrs	1	
Clean Agent	2 Kgs	2	
Clean Agent	2 Kgs	1	Suppression System
ABC & E	580 ML	6	Works Automatically & Manually
	Total Quantity	74	

1. This drawing is a property of De:Ca+Pe Studio and is not to be reproduced copied or handed over in any form except for the purpose for which it is intended.
2. All dimension are in Millimeter except where mentioned.
3. Drawings are not to be scaled written dimensions are to be followed.
4. All discrepancies to be brought to the notice of the Architect and resolved before commencement of any work.

PRODUCED BY AN AUTODESK EDUCATIONAL PRODUCT

Architectural Consultant Ar.GauravGupta	Structural Consultant SBSConsultant
---	---

Electrical Consultant	Plumbing Consultant
-----------------------	---------------------

Client/Owner	BHARAT SEWA SANSTHAN
--------------	----------------------

Project Description CHANDRABHAN GUPT LAW COLLEGE	North 
---	---


Drawing Title	STP DETAILS
---------------	-------------

Date:- 26.08.25
Drawn By:-
Checked By:- Ar. Gaurav Gupta
Scale:-N.T.S

Project Code:-

Sheet No.:-

Office Stamp

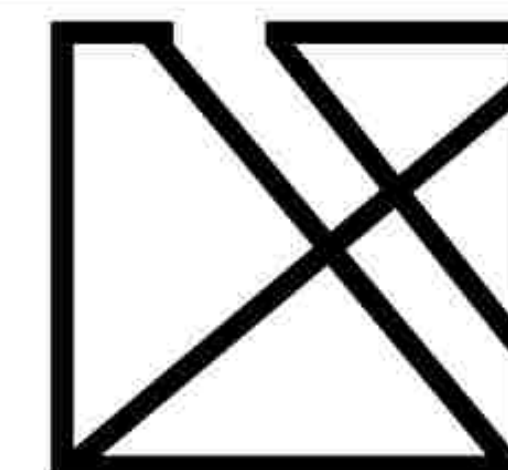

DE: CA+PE STUDIO

Collaborative Architecture & Planning Environment

Head Office - L2-155, SectorG, LDAcolony,Ashiyana

Kanpur Road near Roy Hospital, behind SpringDale School, Lucknow - 226012


Branch Office - 8/1, Basement, Kalkaji extension,
Delhi- 110019

Contact no - +91 99350 05439

E-Mail- studio.decape18@gmail.com
info.decapestudio@gmail.com

NOTE:

1. This drawing is a property of De:Ca+Pe Studio and is not to be reproduced copied or handed over in any form except for the purpose for which it is intended.
2. All dimension are in Millimeter except where mentioned.
3. Drawings are not to be scaled written dimensions are to be followed.
4. All discrepancies to be brought to the notice of the Architect and resolved before commencement of any work.

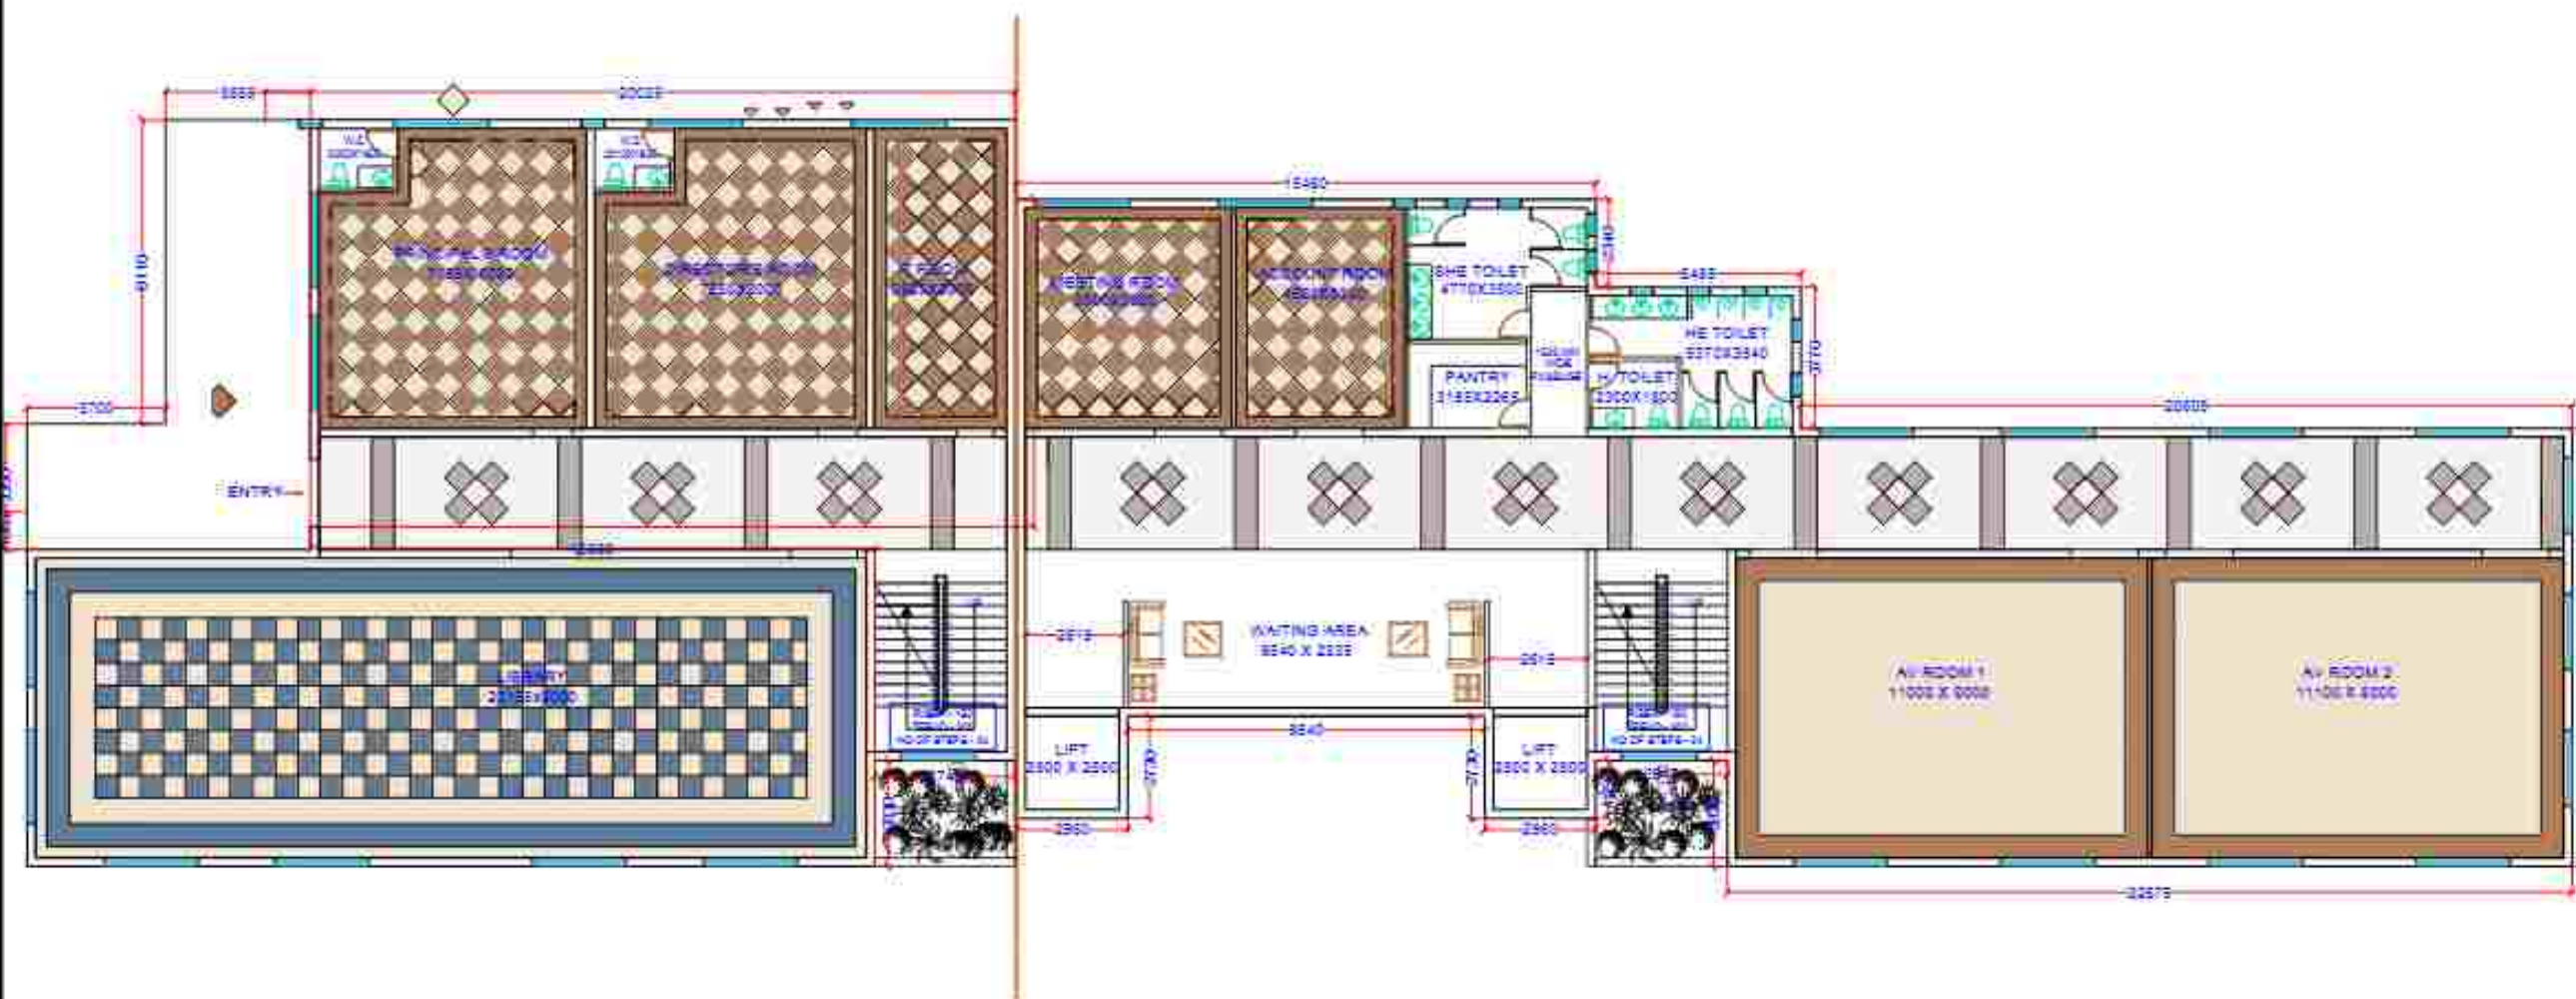

Architectural Consultant: Ar. Gaurav Gupta

Structural Consultant: SRS Consultant

Electrical Consultant: Plumbing Consultant

Client/Owner: BHARAT SEWA SANSTHAN

Project Description: CHANDRABHAN GUPT LAW COLLEGE




Drawing Title

Date:-
Drawn By:-
Checked By:-
Scale:- N.T.S

Project Code:-
Sheet No:-

Office Stamp

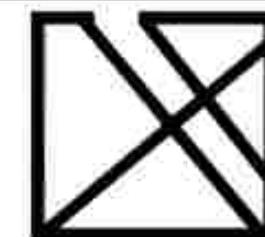

DE: CA+PE STUDIO

Collaborative Architecture & Planning Environment


Head Office - L2-155, Sector G, LDA colony, Ashiyana
Kanpur Road near Roy Hospital, behind Spring Dale
School, Lucknow - 226012

Branch Office - 8/1, Basement, Kalkaji extension,
Delhi - 110019


Contact no - +91 99350 05439

E-Mail- studio.decape18@gmail.com

info.decapestudio@gmail.com

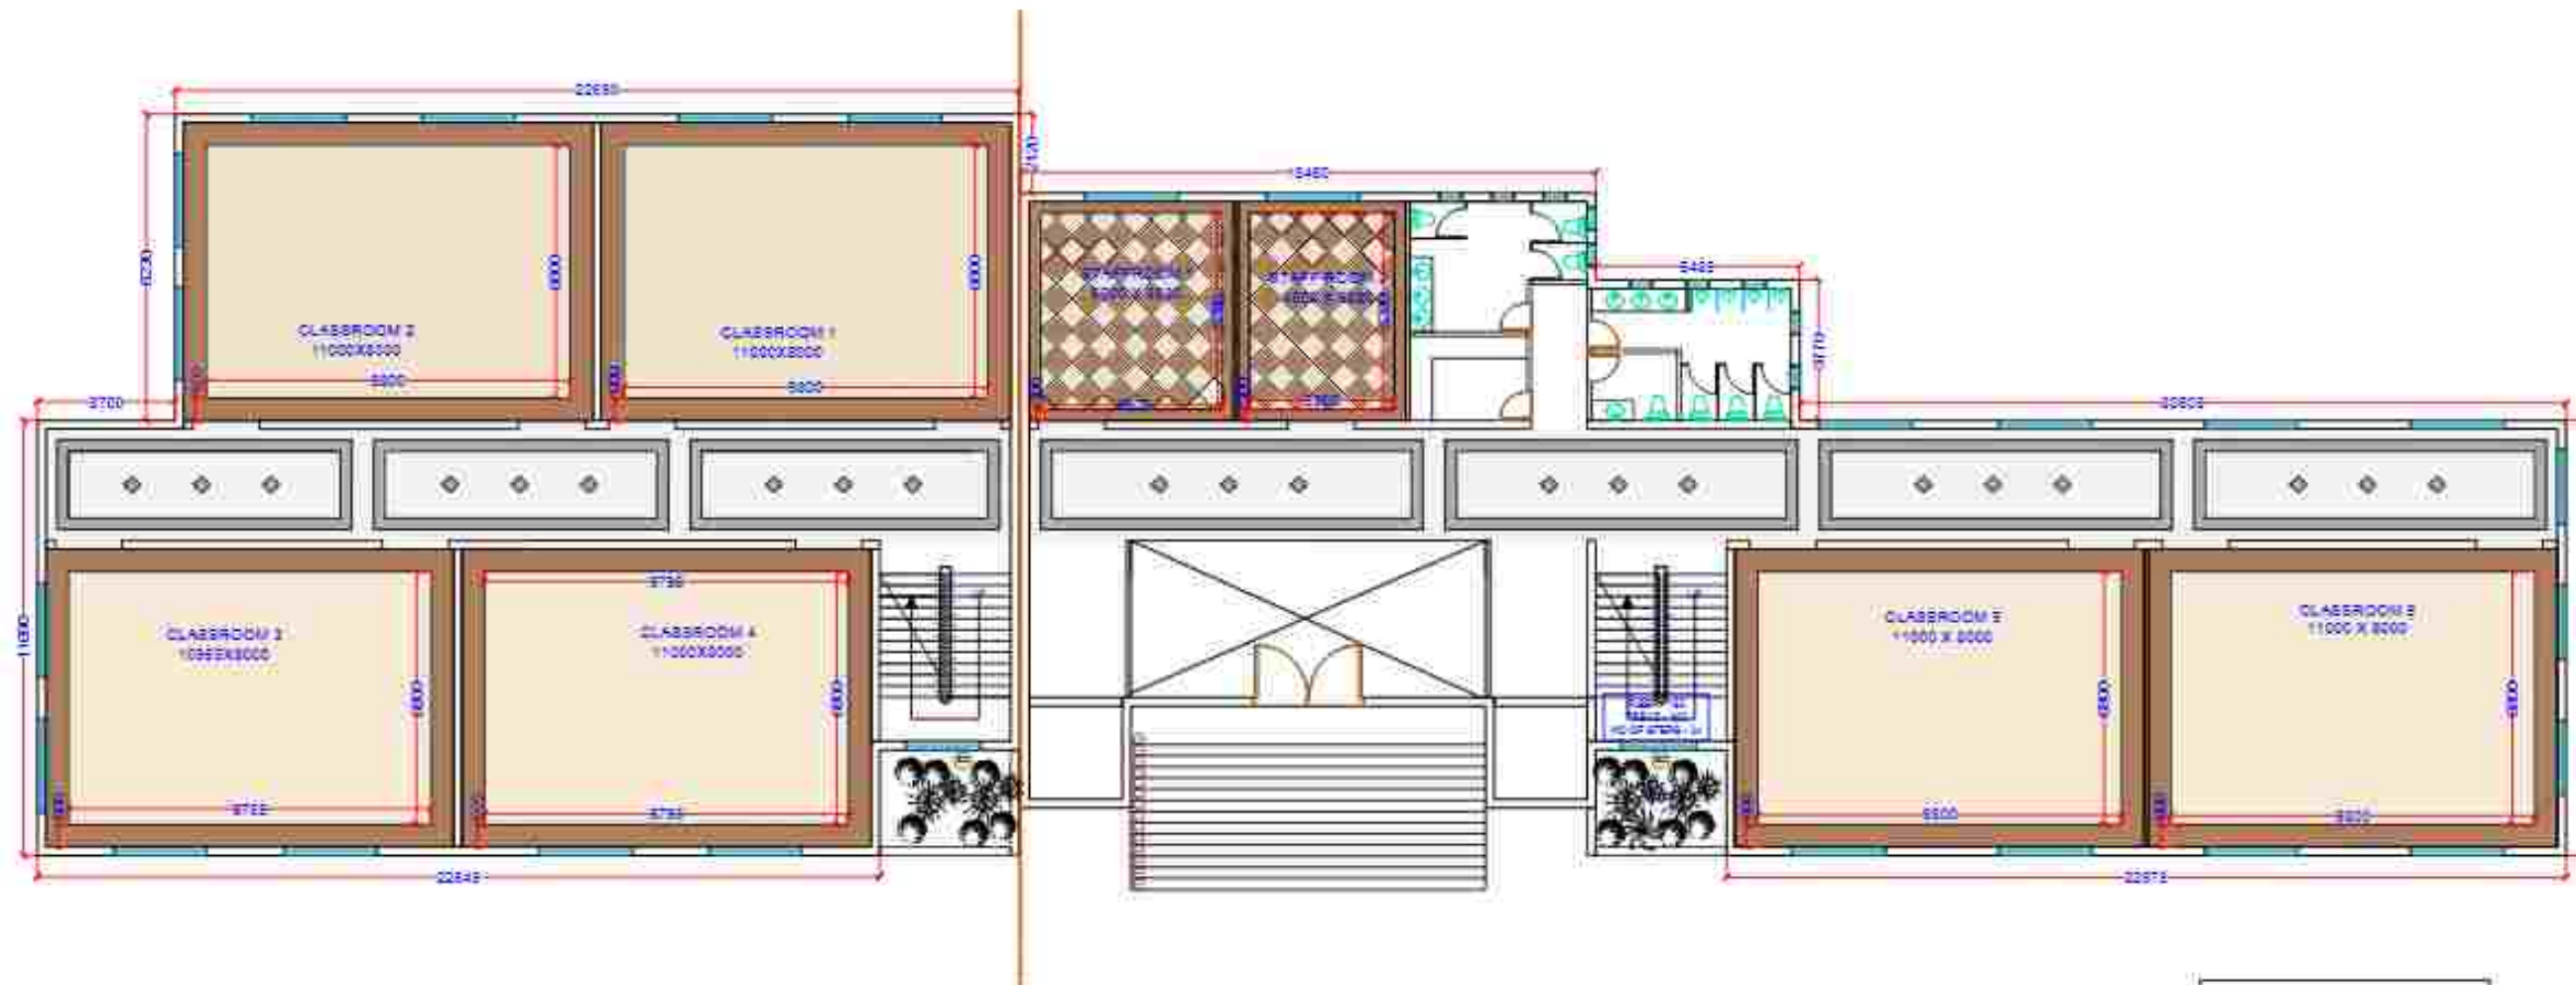

UPPER GROUND FLOOR (1:300)

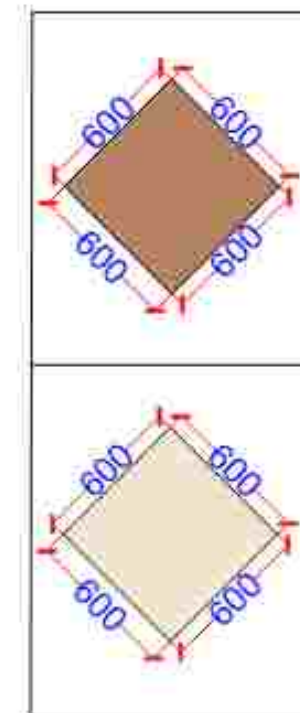

NOTE:

1. This drawing is a property of De:Ca+Pe Studio and is not to be reproduced copied or handed over in any form except for the purpose for which it is intended.
2. All dimension are in Millimeter except where mentioned.
3. Drawings are not to be scaled written dimensions are to be followed.
4. All discrepancies to be brought to the notice of the Architect and resolved before commencement of any work.

Architectural Consultant
Ar. Gaurav Gupta

Structural Consultant
SBS Consultant

Electrical Consultant
Plumbing Consultant

Client/Owner
BHARAT SEWA SANSTHAN

Project Description
CHANDRABHAN GUPTA
LAW COLLEGE




Drawing Title

Date:-
Drawn By:-
Checked By:-
Scale:- N.T.S

Project Code:-
Sheet No.:-

Office Stamp

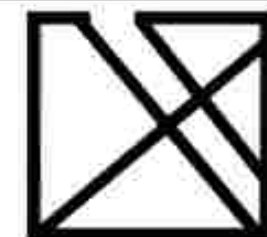

DE: CA+PE STUDIO

Collaborative Architecture & Planning Environment

Head Office - L2-155, Sector G, LDA colony, Ashiyana
Kanpur Road near Roy Hospital, behind Spring Dale
School, Lucknow - 226012

Branch Office - 8/1, Basement, Kalkaji extension,
Delhi - 110019


Contact no - +91 99350 05439

E-Mail- studio.decape18@gmail.com


info.decapestudio@gmail.com

NOTE:

1. This drawing is a property of De:Ca+Pe Studio and is not to be reproduced copied or handed over in any form except for the purpose for which it is intended.
2. All dimension are in Millimeter except where mentioned.
3. Drawings are not to be scaled written dimensions are to be followed.
4. All discrepancies to be brought to the notice of the Architect and resolved before commencement of any work.

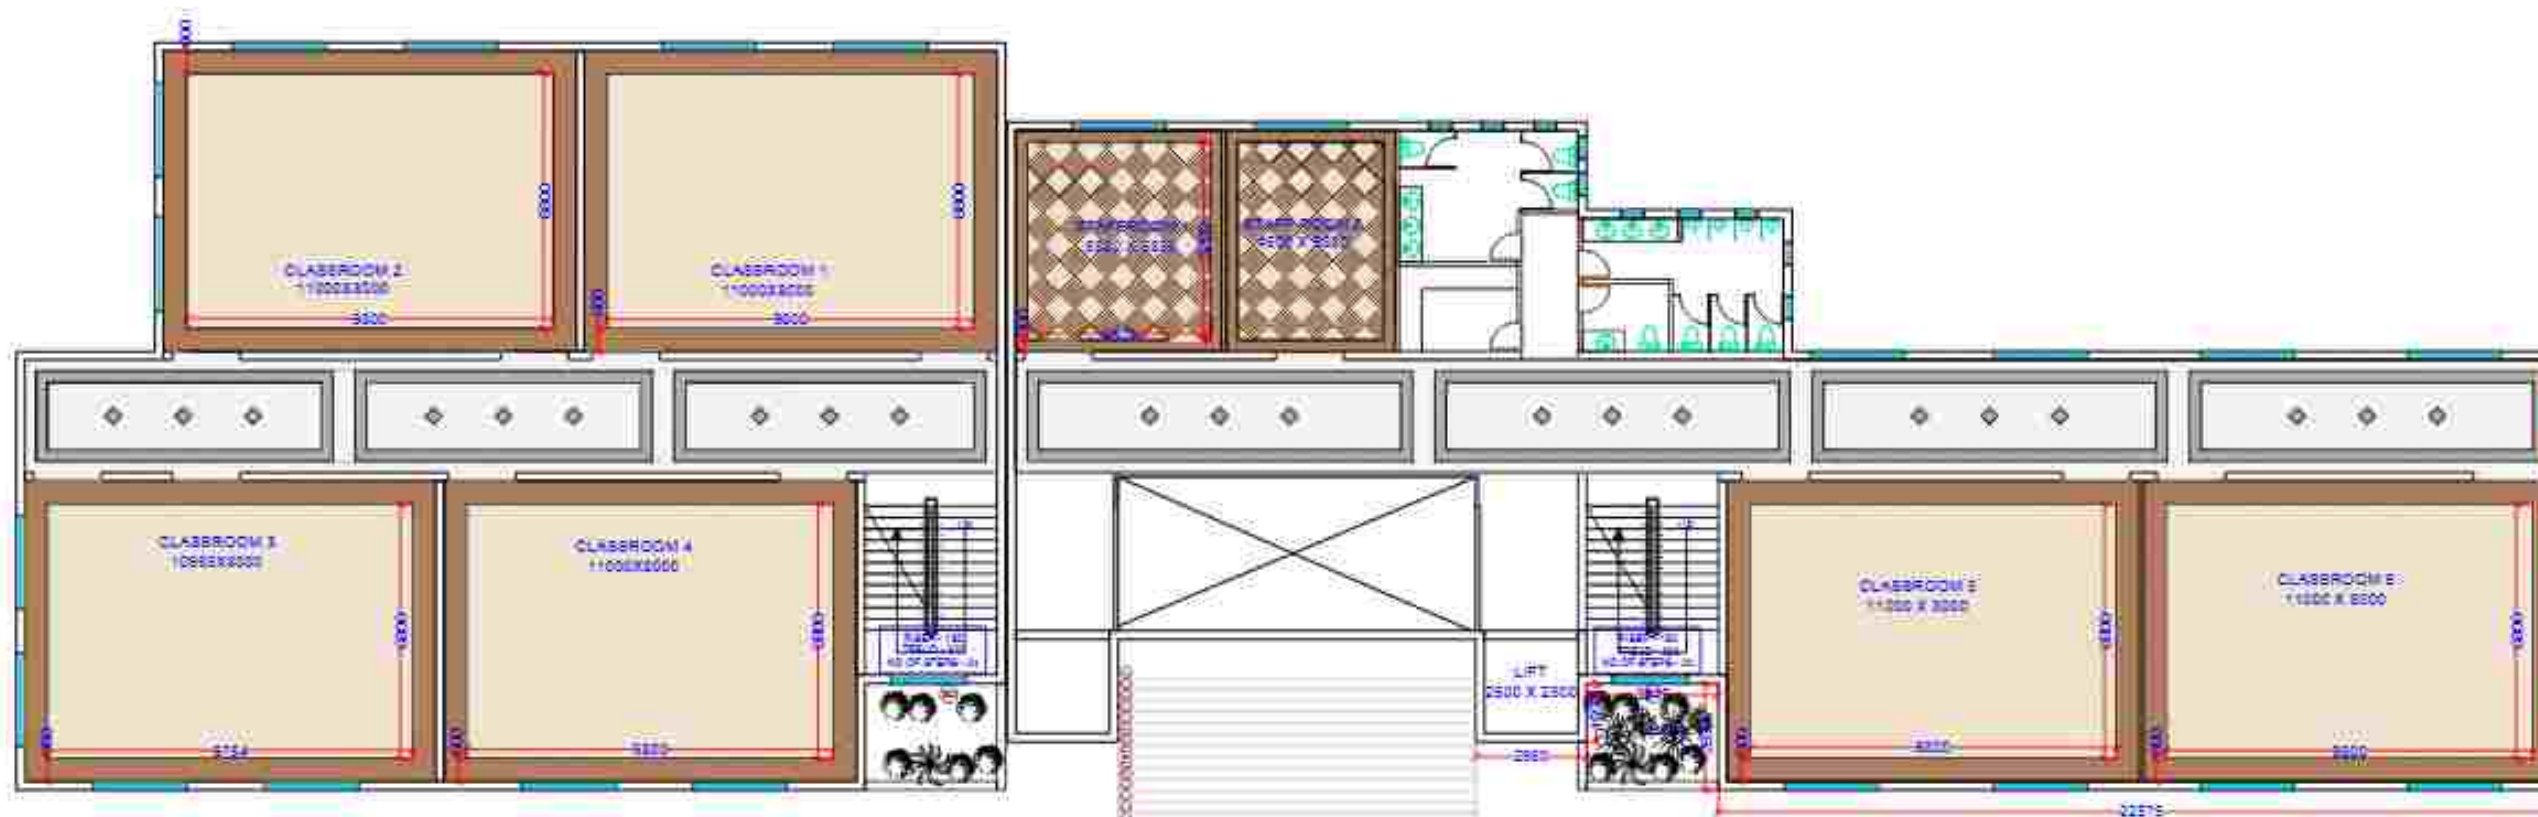

FIRST FLOOR (1:300)

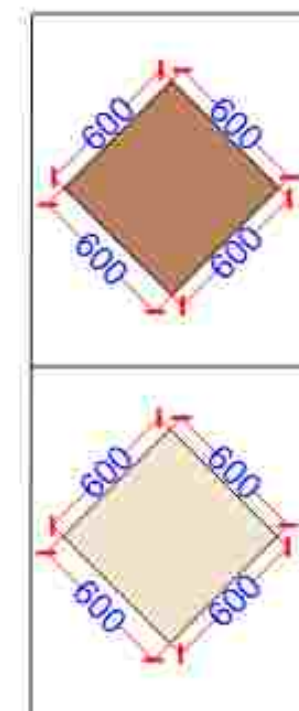


Architectural Consultant
Ar. Gaurav Gupta

Structural Consultant
SBS Consultant

Electrical Consultant
Plumbing Consultant

Client/Owner
BHARAT SEWA SANSTHAN

 Project Description
CHANDRABHAN GUPT
LAW COLLEGE




Drawing Title

Date:-
Drawn By:-
Checked By:-
Scale:-N.T.S

Project Code:-
Sheet No.:-

Office Stamp

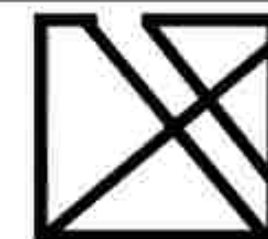

DE: CA+PE STUDIO

Collaborative Architecture & Planning Environment


Head Office - L2-155, Sector G, LDA colony, Ashiyana
Kanpur Road near Roy Hospital, behind Spring Dale
School, Lucknow - 226012

Branch Office - 8/1, Basement, Kalkaji extension,
Delhi - 110019


Contact no - +91 99350 05439

E-Mail- studio.decape18@gmail.com

info.decapestudio@gmail.com

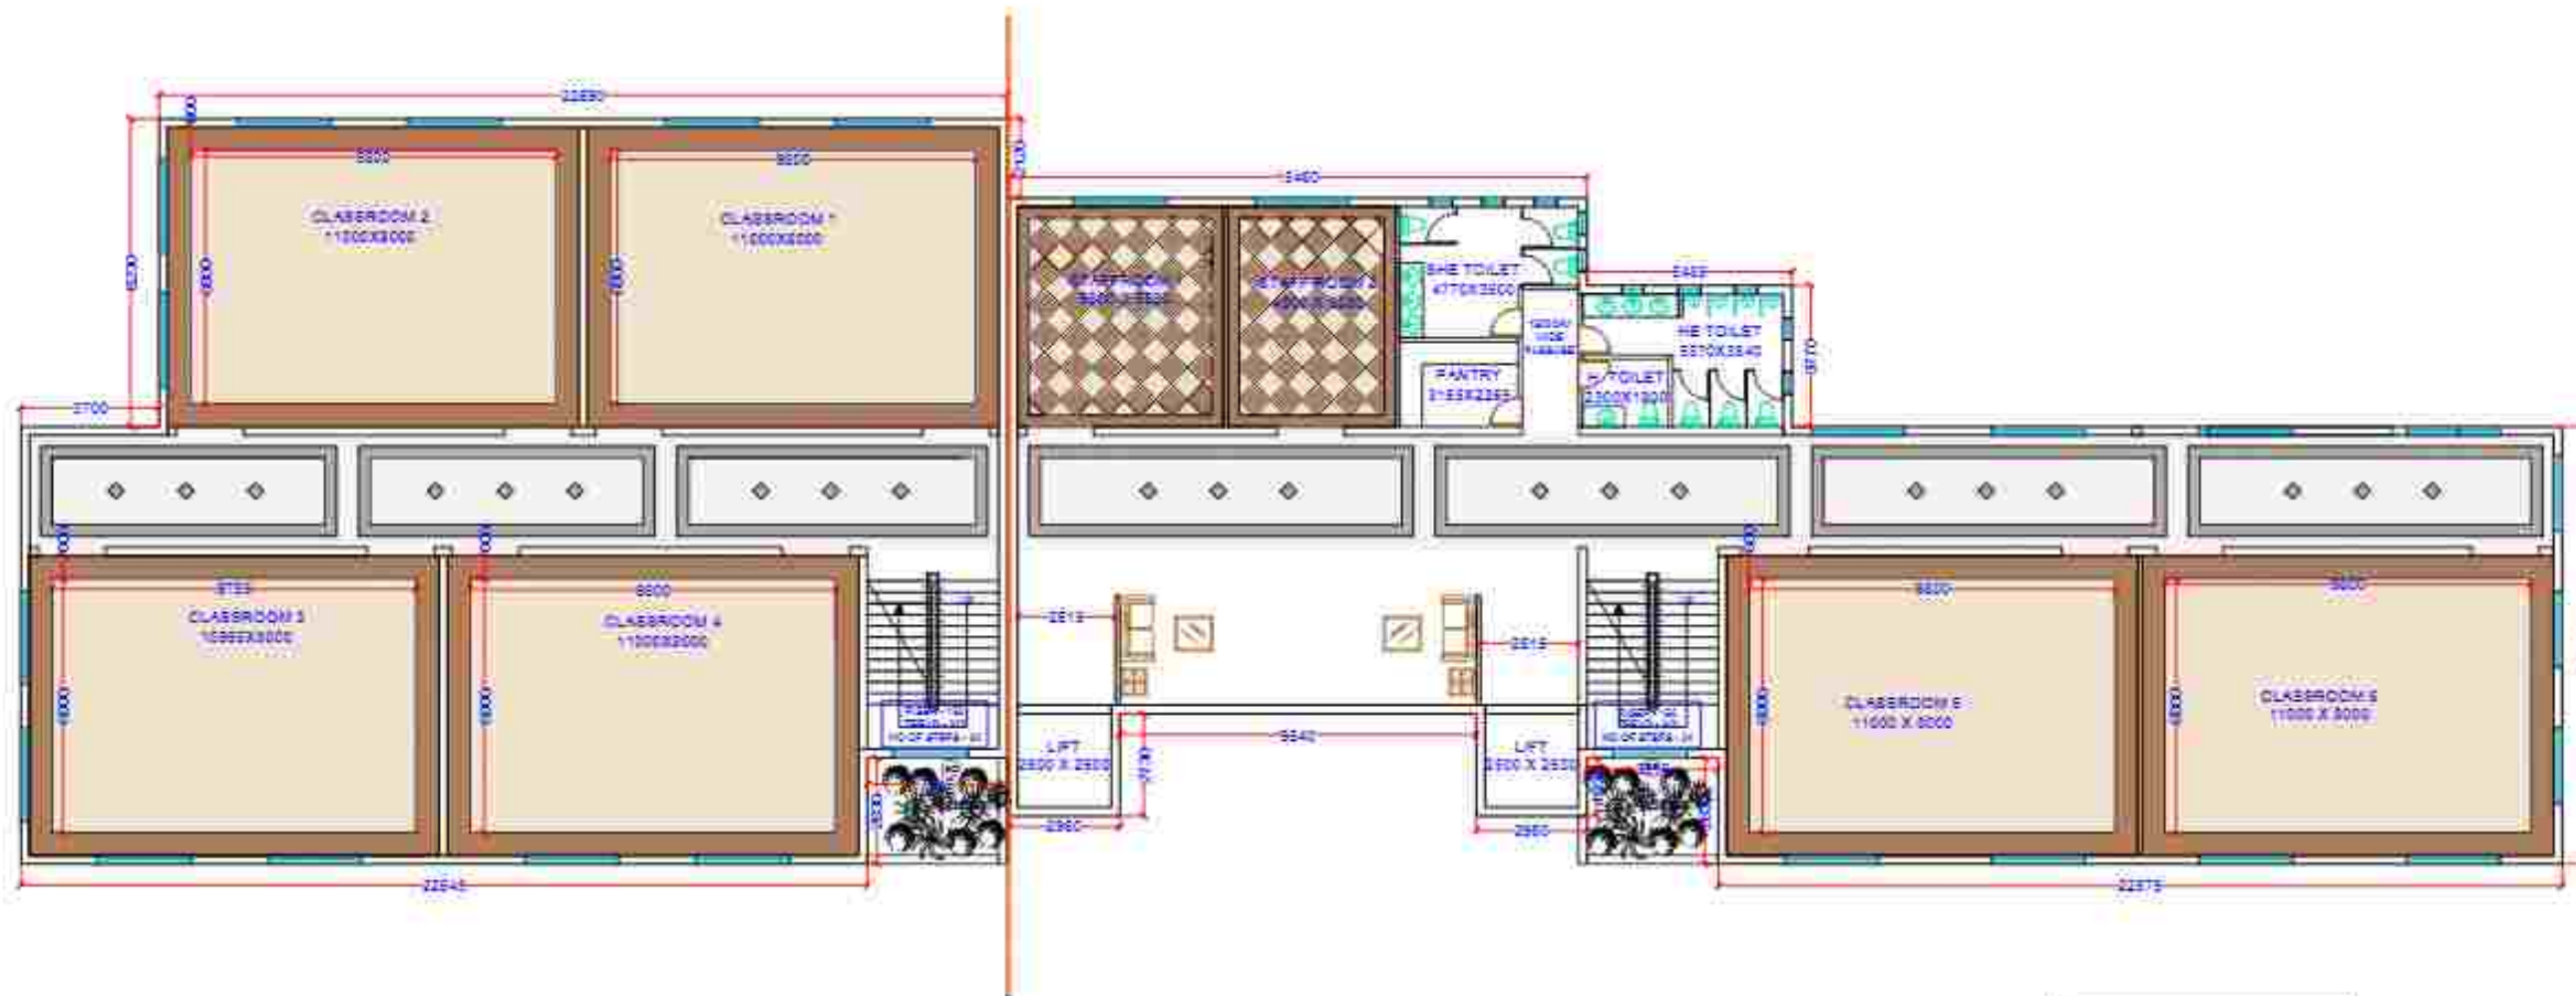

SECOND FLOOR (1:300)

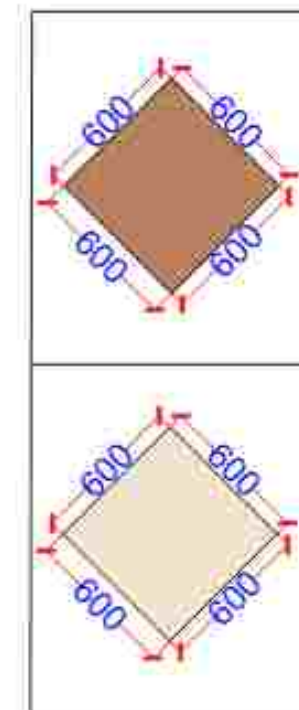

NOTE:

1. This drawing is a property of De:Ca+Pe Studio and is not to be reproduced copied or handed over in any form except for the purpose for which it is intended.
2. All dimension are in Millimeter except where mentioned.
3. Drawings are not to be scaled written dimensions are to be followed.
4. All discrepancies to be brought to the notice of the Architect and resolved before commencement of any work.

Architectural Consultant: Ar. Gaurav Gupta

Structural Consultant: SRS Consultant

Electrical Consultant: Plumbing Consultant

Client/Owner: BHARAT SEWA SANSTHAN

Project Description: CHANDRABHAN GUPT LAW COLLEGE




Drawing Title

Date:-
Drawn By:-
Checked By:-
Scale:- N.T.S

Project Code:-
Sheet No.:-

Office Stamp

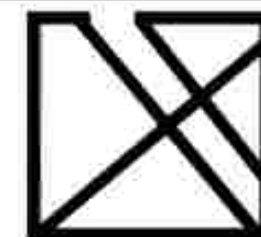

DE: CA+PE STUDIO

Collaborative Architecture & Planning Environment

Head Office - L2-155, Sector G, LDA colony, Ashiyana Kanpur Road near Roy Hospital, behind Spring Dale School, Lucknow - 226012

Branch Office - 8/1, Basement, Kalkaji extension, Delhi - 110019

Contact no - +91 99350 05439

E-Mail- studio.decape18@gmail.com

info.decapestudio@gmail.com

NOTE:

1. This drawing is a property of De Ca+Pe Studio and is not to be reproduced copied or handed over in any form except for the purpose for which it is intended.
2. All dimension are in Feet/inches except where mentioned.
3. Drawings are not to be scaled written dimensions are to be followed.
4. All discrepancies to be brought to the notice of the Architect and resolved before commencement of any work.

S.NO	SYMBOL	DESCRIPTION
1.		1100 VERTICAL WASTE PIPE
2.		1100 VERTICAL SOIL WATER PIPE
3.		110 Ø HORIZONTAL WASTE PIPE
4.		110 Ø HORIZONTAL SOIL WATER PIPE
5.		LC PIPE
6.		FLOOR TRAP
7.		INSPECTION CHAMBER (1'5"X1'-6")
8.		SEWAGE TANK
9.		STP

Architectural Consultant	Structural Consultant
Ar. Gaurav Gupta	SBS Consultant

Electrical Consultant	Plumbing Consultant
-----------------------	---------------------

Client/Owner
BHARAT SEWA SANSTHAN


Project Description CHANDRABHAN GUPT LAW COLLEGE	North
--	-------

Drawing Title
LAW COLLEGE-
PLUMBING (FIRST FLOOR)

Date:-
Drawn By:-
Checked By:-
Scale:-

Project Code:-
Sheet No.:-

Office Stamp

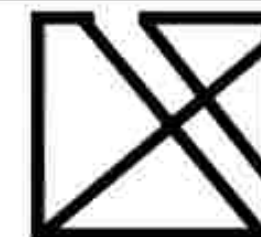

DE: CA+PE STUDIO

Collaborative Architecture & Planning Environment


Head Office - L2-155, Sector G, LDA colony, Ashiyana
Kanpur Road near Roy Hospital, behind Spring Dale
School, Lucknow - 226012

Branch Office - 8/1, Basement, Kalkaji extension,
Delhi - 110019

Contact no - +91 99350 05439

E-Mail- studio.decape18@gmail.com

info.decapestudio@gmail.com

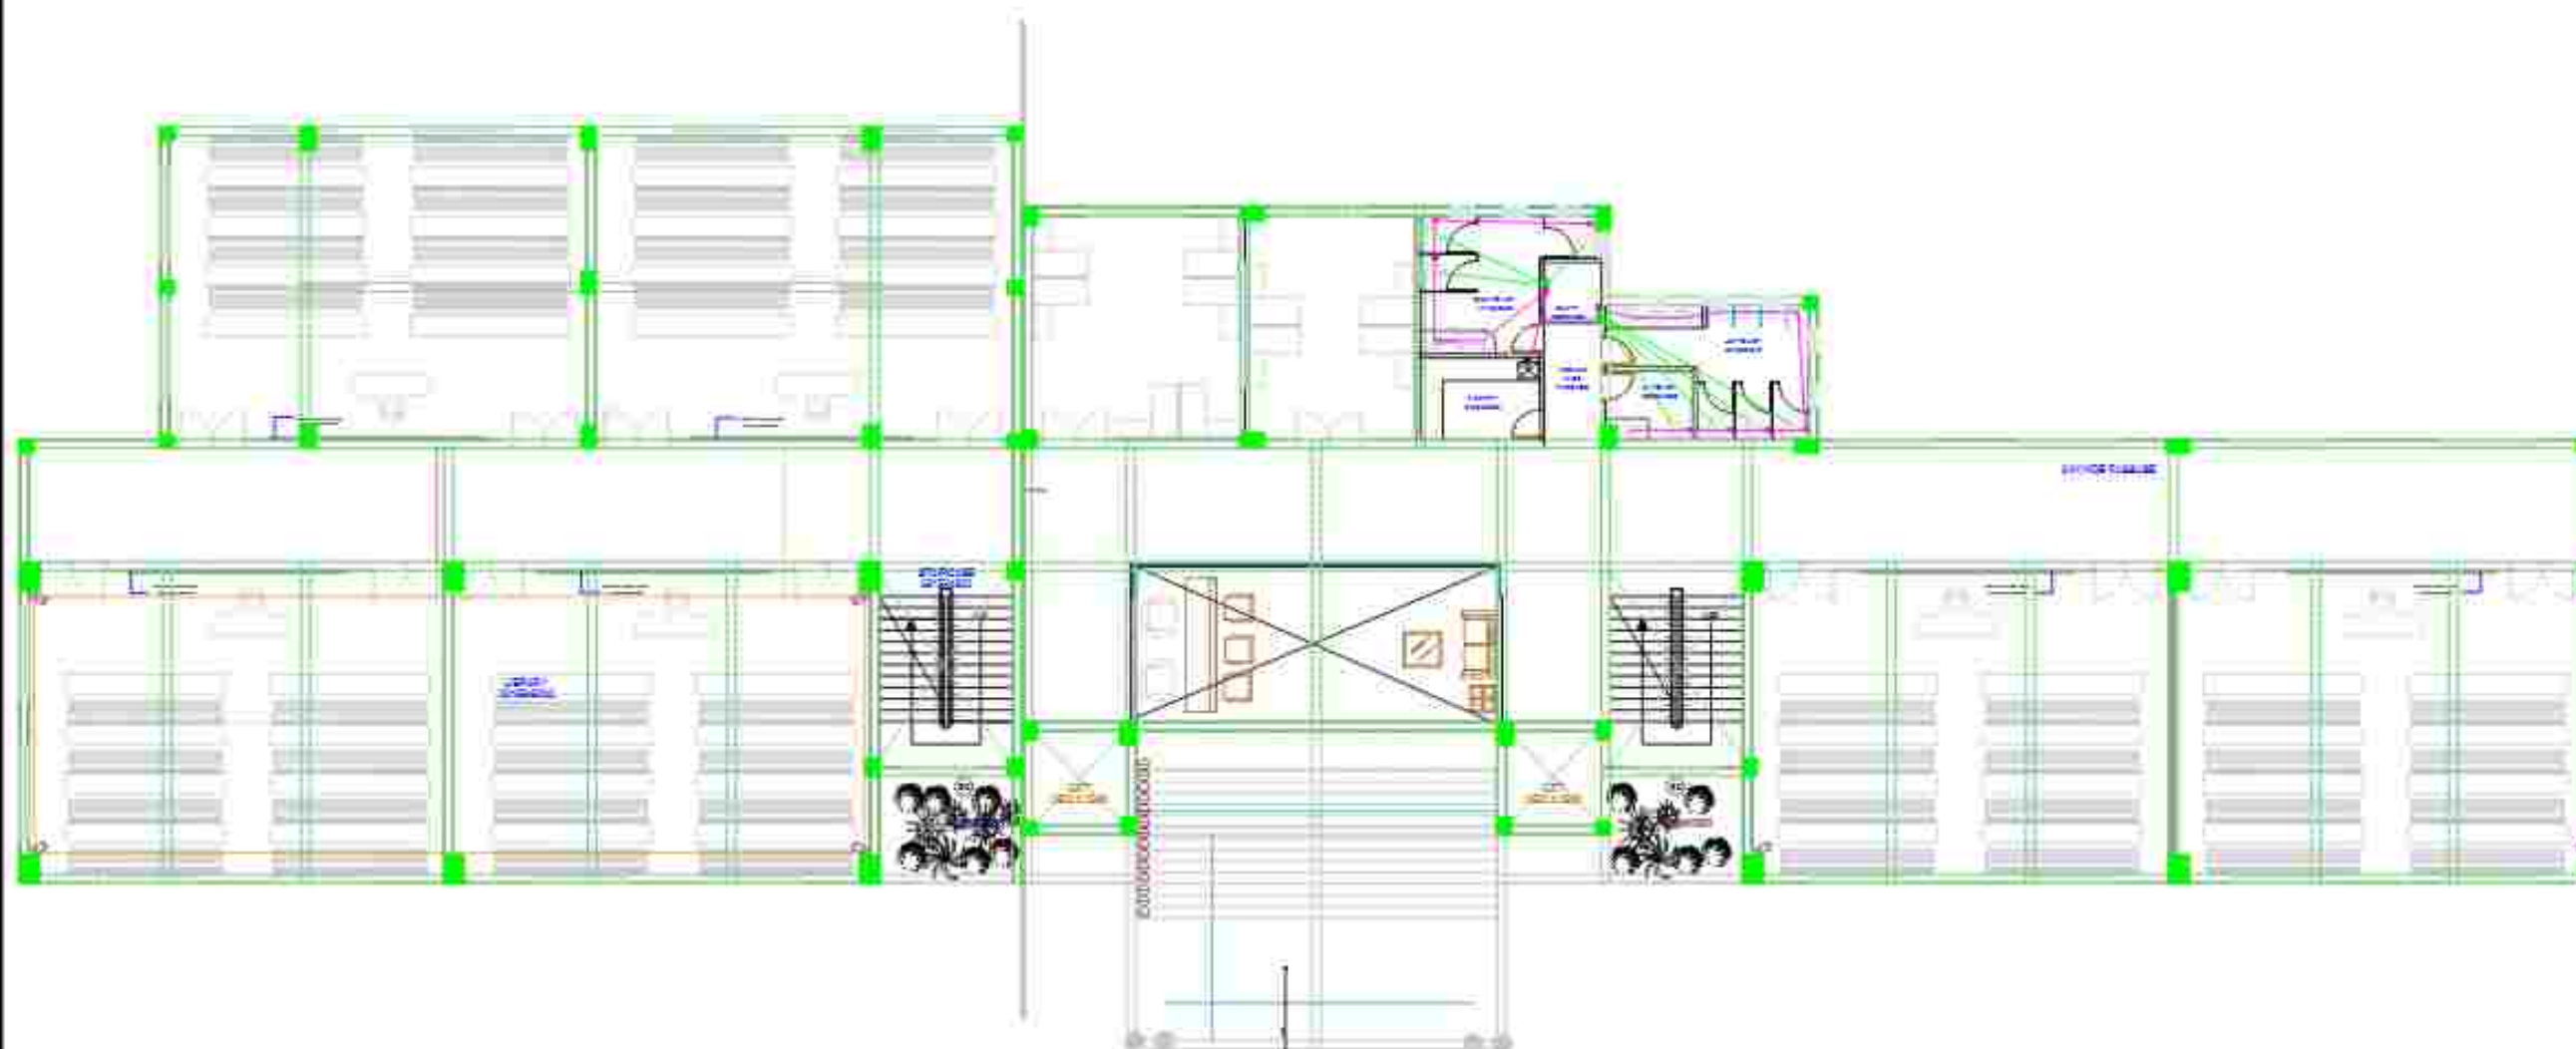

FIRST FLOOR (1:300)

NOTE:

1. This drawing is a property of De Ca+Pe Studio and is not to be reproduced copied or handed over in any form except for the purpose for which it is intended.
2. All dimension are in Feet/inches except where mentioned.
3. Drawings are not to be scaled written dimensions are to be followed.
4. All discrepancies to be brought to the notice of the Architect and resolved before commencement of any work.

S.NO	SYMBOL	DESCRIPTION
1.		1100 VERTICAL WASTE PIPE
2.		1100 VERTICAL SOIL WATER PIPE
3.		110 Ø HORIZONTAL WASTE PIPE
4.		110 Ø HORIZONTAL SOIL WATER PIPE
5.		LC PIPE
6.		FLOOR TRAP
7.		INSPECTION CHAMBER (1'-6"X1'-6")
8.		SEWAGE TANK
9.		STP

Architectural Consultant Ar. Gaurav Gupta	Structural Consultant SBS Consultant
--	---

Electrical Consultant	Plumbing Consultant
-----------------------	---------------------

Client/Owner
BHARAT SEWA SANSTHAN


Project Description CHANDRABHAN GUPT LAW COLLEGE	North
--	-------

Drawing Title
LAW COLLEGE-
PLUMBING (SECOND FLOOR)

Date:-
Drawn By:-
Checked By:-
Scale:-

Project Code:-
Sheet No.:-

Office Stamp

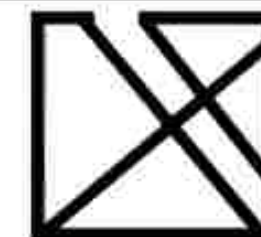

DE: CA+PE STUDIO

Collaborative Architecture & Planning Environment


Head Office - L2-155, Sector G, LDA colony, Ashiyana
Kanpur Road near Roy Hospital, behind Spring Dale
School, Lucknow - 226012

Branch Office - 8/1, Basement, Kalkaji extension,
Delhi - 110019

Contact no - +91 99350 05439

E-Mail- studio.decape18@gmail.com

info.decapestudio@gmail.com

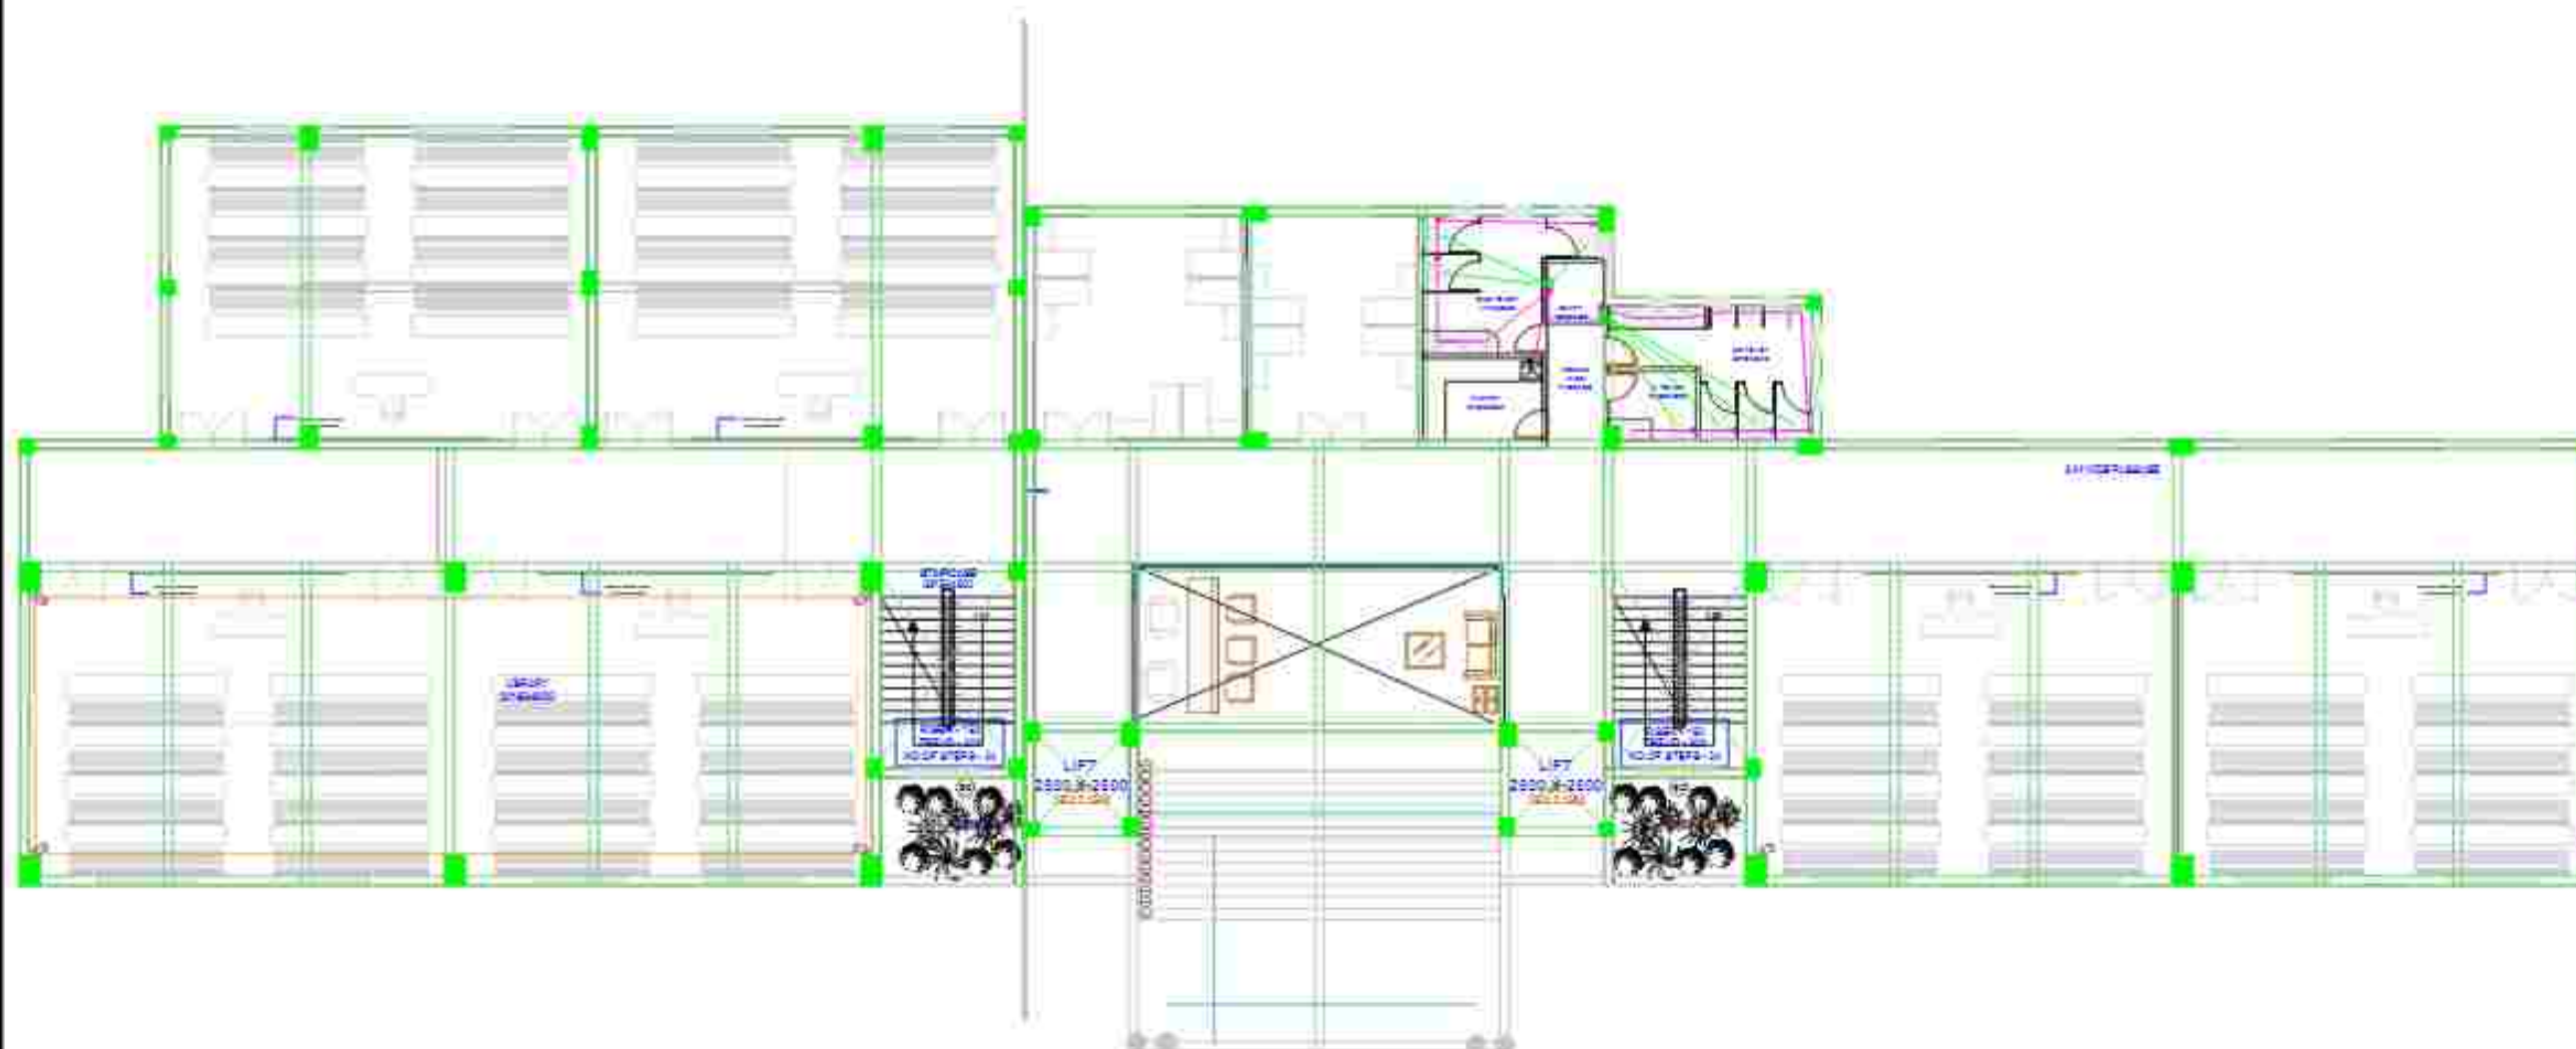

SECOND FLOOR (1:300)

NOTE:

1. This drawing is a property of De Ca+Pe Studio and is not to be reproduced copied or handed over in any form except for the purpose for which it is intended.
2. All dimension are in Feet/inches except where mentioned.
3. Drawings are not to be scaled written dimensions are to be followed.
4. All discrepancies to be brought to the notice of the Architect and resolved before commencement of any work.

S.NO.	SYMBOL	DESCRIPTION
1.		110Ø VERTICAL WASTE PIPE
2.		110Ø VERTICAL SOIL WATER PIPE
3.		110 Ø HORIZONTAL WASTE PIPE
4.		110 Ø HORIZONTAL SOIL WATER PIPE
5.		10 PIPE
6.		FLOOR TRAP
7.		INSPECTION CHAMBER (1'-5"X1'-5")
8.		SEWAGE TANK
9.		STP

Architectural Consultant	Structural Consultant
Ar. Gaurav Gupta	SBS Consultant

Electrical Consultant	Plumbing Consultant
-----------------------	---------------------

Client/Owner
BHARAT SEWA SANSTHAN


Project Description CHANDRABHAN GUPT LAW COLLEGE	North
--	-------

Drawing Title
LAW COLLEGE-
PLUMBING (UPPER GROUND FLOOR)

Date:-
Drawn By:-
Checked By:-
Scale:-

Project Code:-
Sheet No.:-

Office Stamp

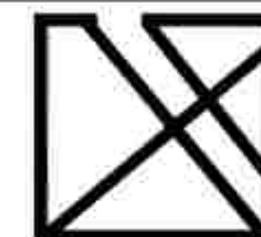

DE: CA+PE STUDIO

Collaborative Architecture & Planning Environment

Head Office - L2-155, Sector G, LDA colony, Ashiyana
Kanpur Road near Roy Hospital, behind Spring Dale
School, Lucknow - 226012


Branch Office - 8/1, Basement, Kalkaji extension,
Delhi - 110019

Contact no - +91 99350 05439

E-Mail- studio.decape18@gmail.com

info.decapestudio@gmail.com

UPPER GROUND FLOOR

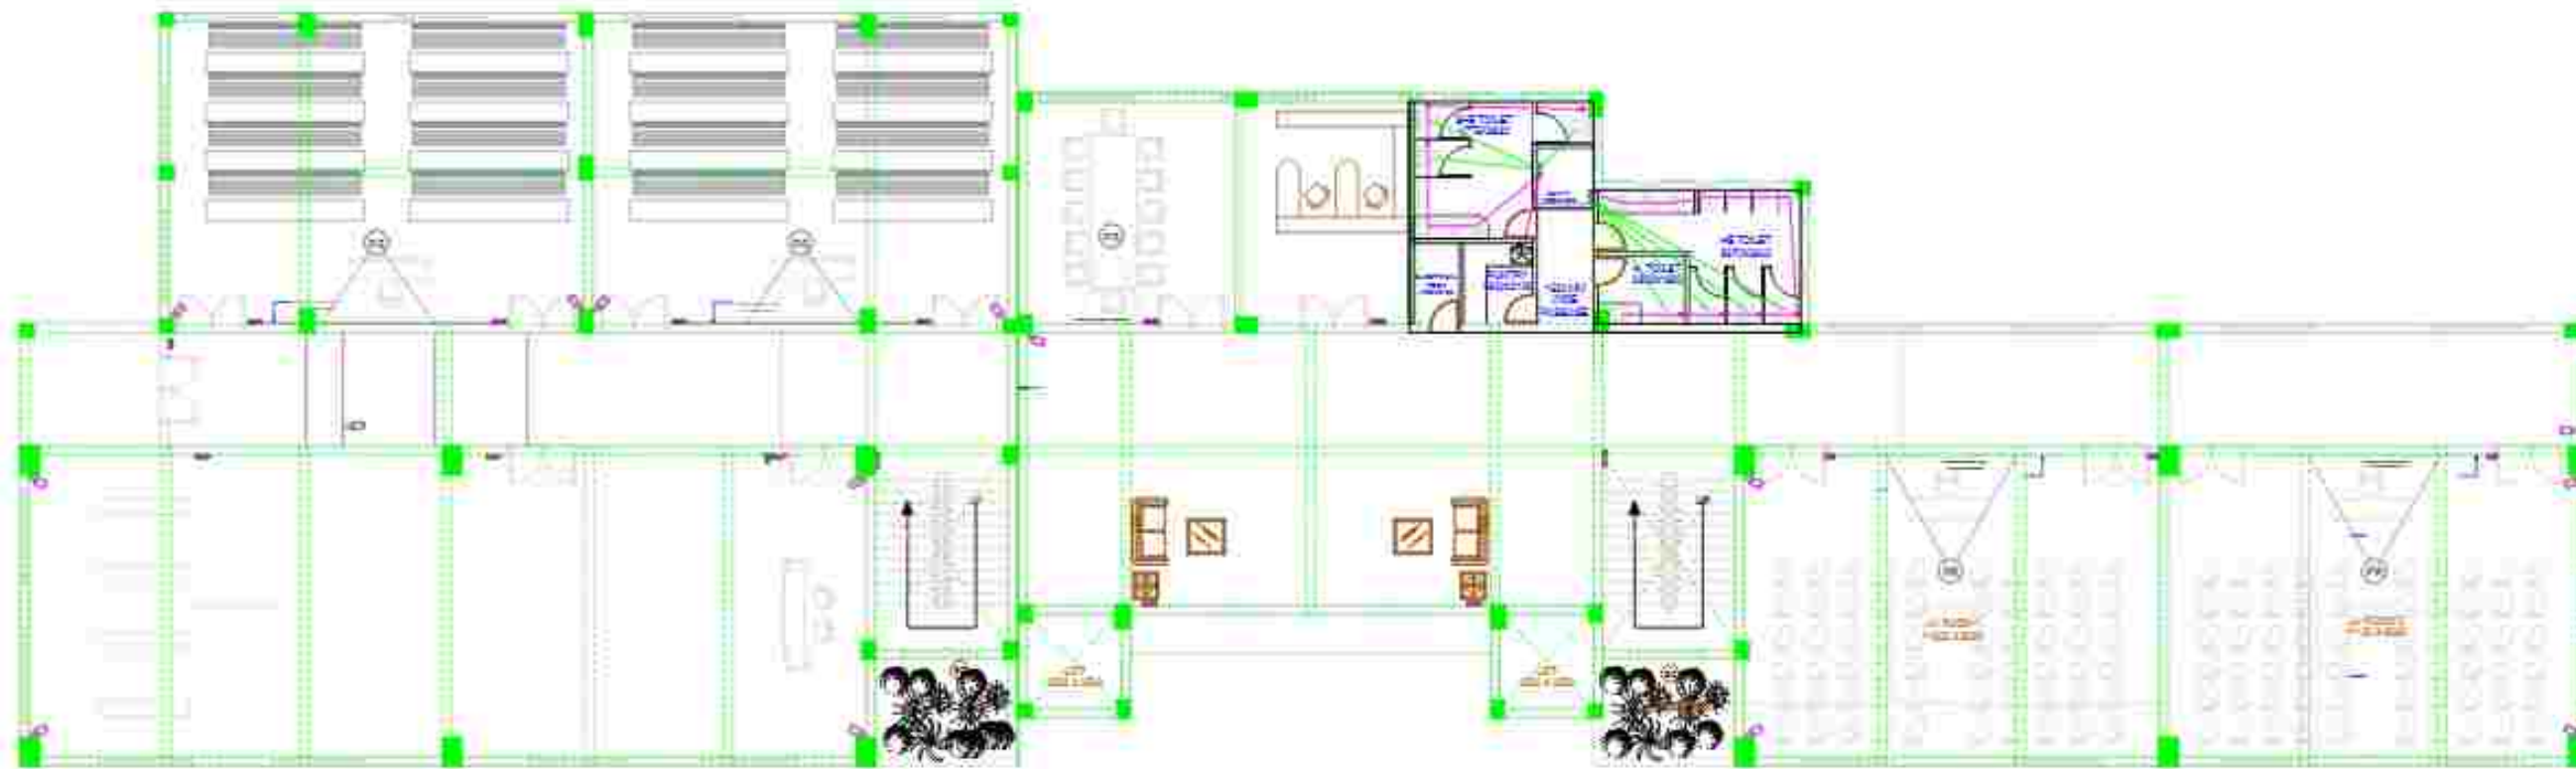

LOWER GROUND FLOOR

NOTE:

1. This drawing is a property of De Ca+Pe Studio and is not to be reproduced copied or handed over in any form except for the purpose for which it is intended.
2. All dimension are in Feet/inches except where mentioned.
3. Drawings are not to be scaled written dimensions are to be followed.
4. All discrepancies to be brought to the notice of the Architect and resolved before commencement of any work.

S.NO.	SYMBOL	DESCRIPTION
1.		1 1/2" VERTICAL WASTE PIPE
2.		1 1/2" VERTICAL SOIL WATER PIPE
3.		1 1/2" HORIZONTAL WASTE PIPE
4.		1 1/2" HORIZONTAL SOIL WATER PIPE
5.		1" C.W. PIPE
6.		FLOOR TRAP
7.		INSPECTION CHAMBER (1'-6" X 1'-6")
8.		SEWAGE TANK
9.		STP

Architectural Consultant: Ar. Gaurav Gupta

Structural Consultant: SBS Consultant

Electrical Consultant:

Plumbing Consultant:

Client/Owner: BHARAT SEWA SANSTHAN

Project Description: CHANDRABHAN GUPT LAW COLLEGE

North

Drawing Title: LAW COLLEGE- PLUMBING (LOWER GROUND FLOOR)

Date:-
Drawn By:-
Checked By:-
Scale:-

Project Code:-
Sheet No.:-

Office Stamp



DE: CA+PE STUDIO

Collaborative Architecture & Planning Environment

Head Office - L2-155, Sector G, LDA colony, Ashiyana Kanpur Road near Roy Hospital, behind Spring Dale School, Lucknow - 226012

Branch Office - 8/1, Basement, Kalkaji extension, Delhi - 110019

Contact no - +91 99350 05439

E-Mail- studio.decape18@gmail.com

info.decapestudio@gmail.com